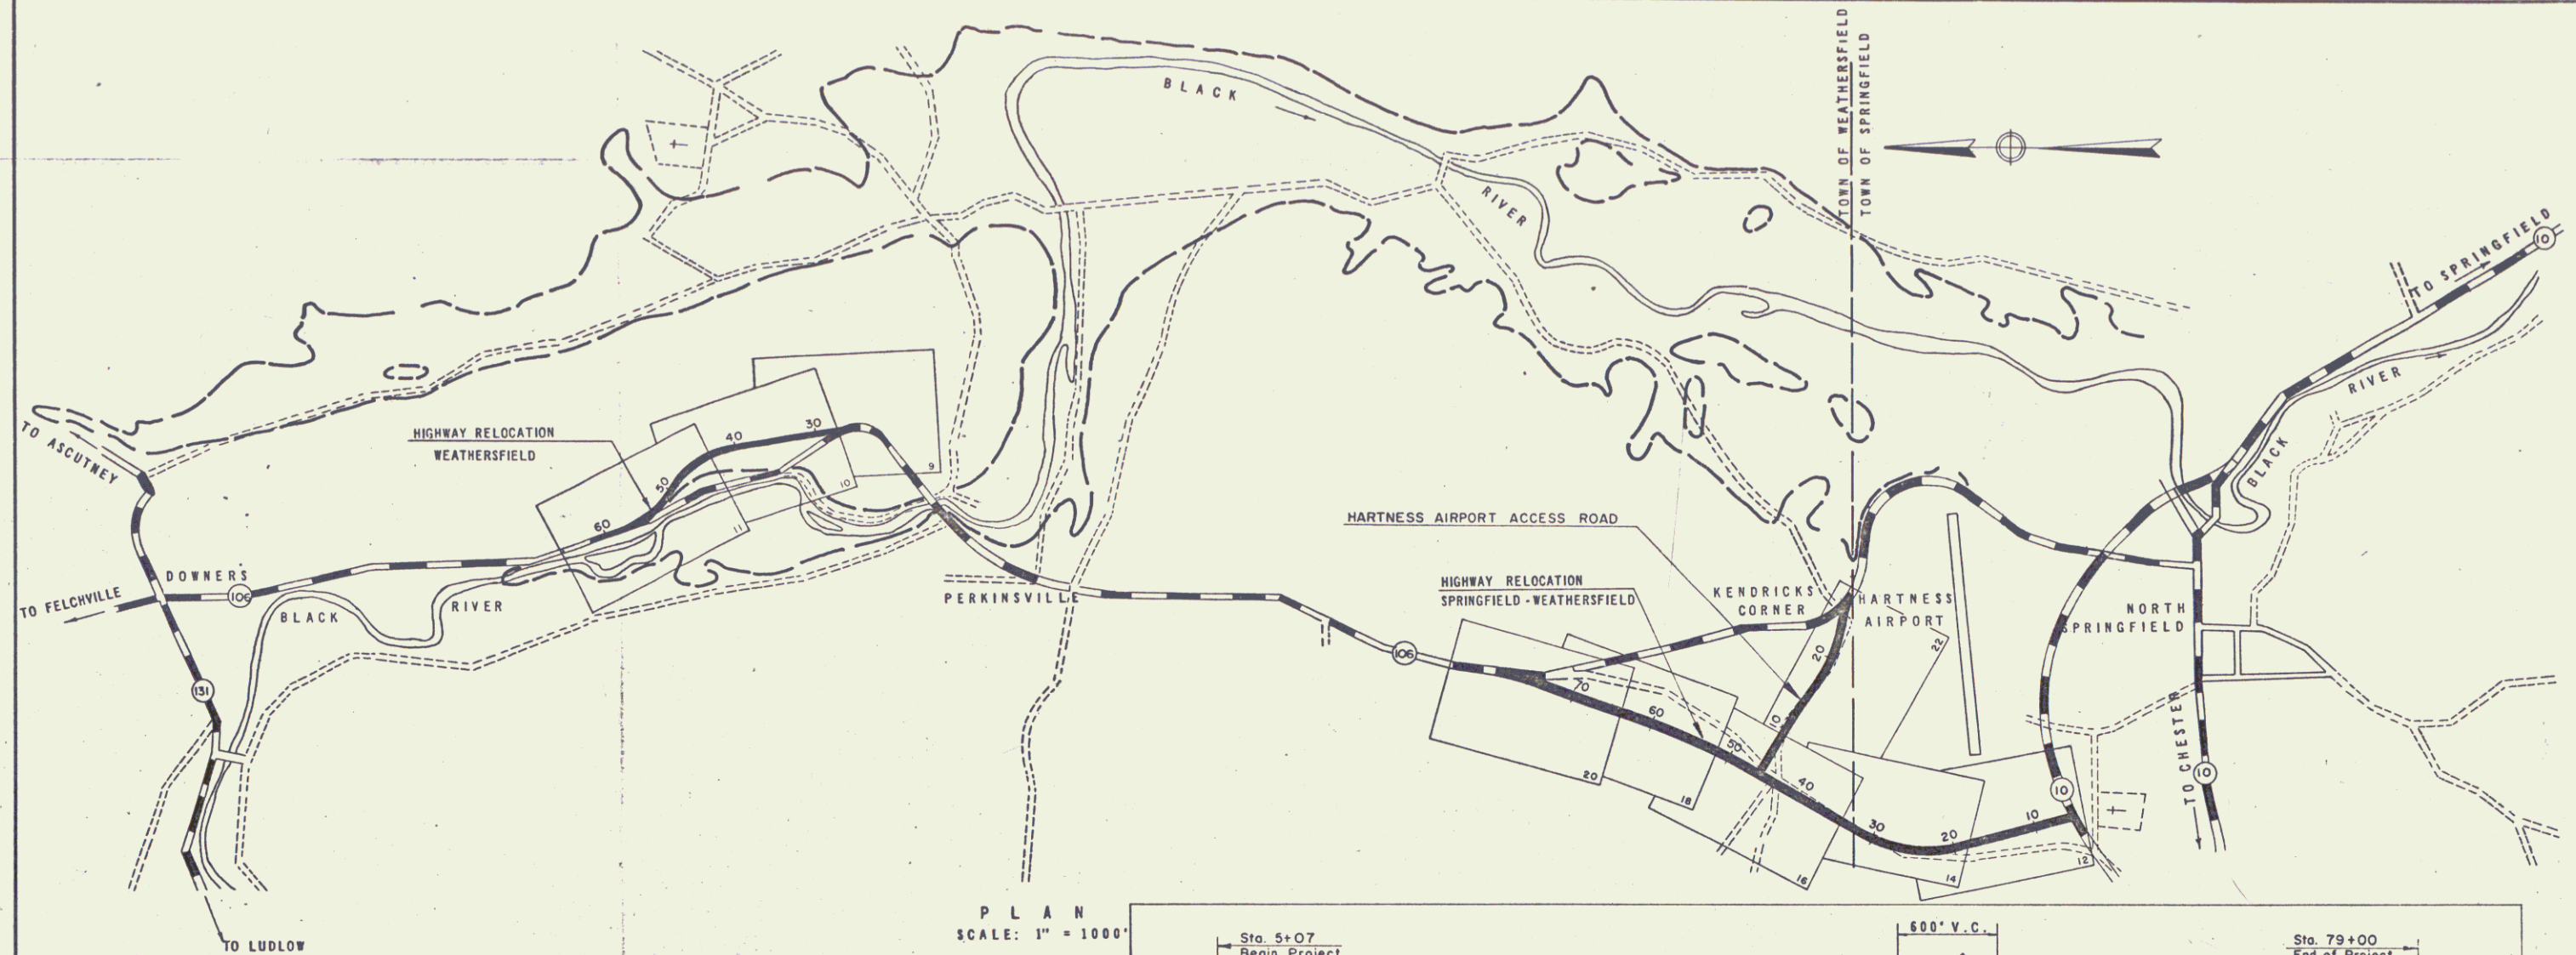
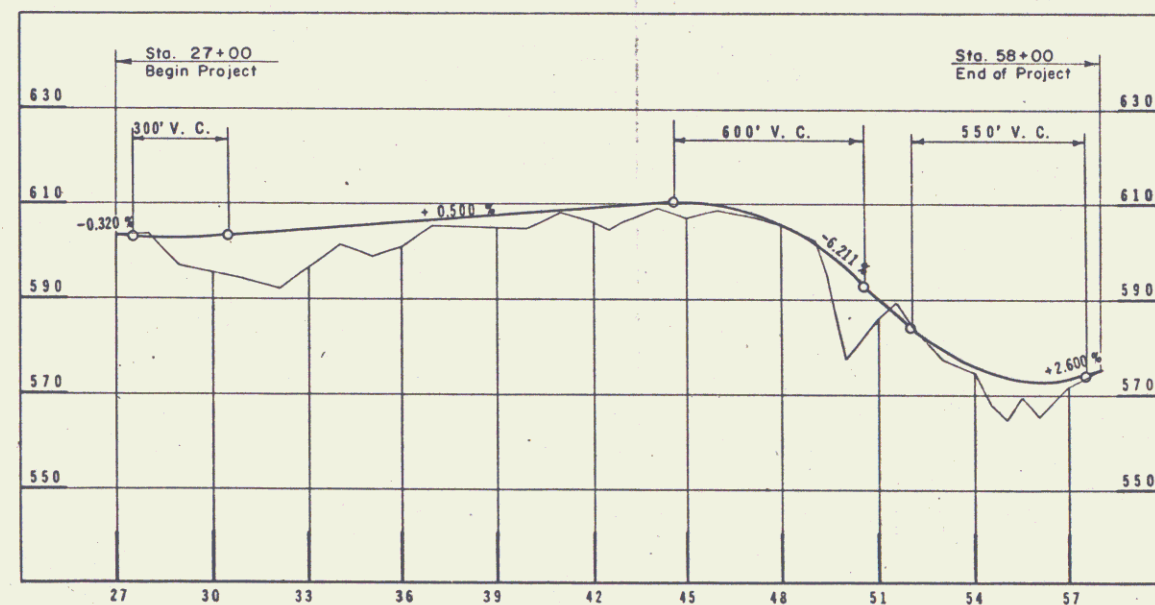
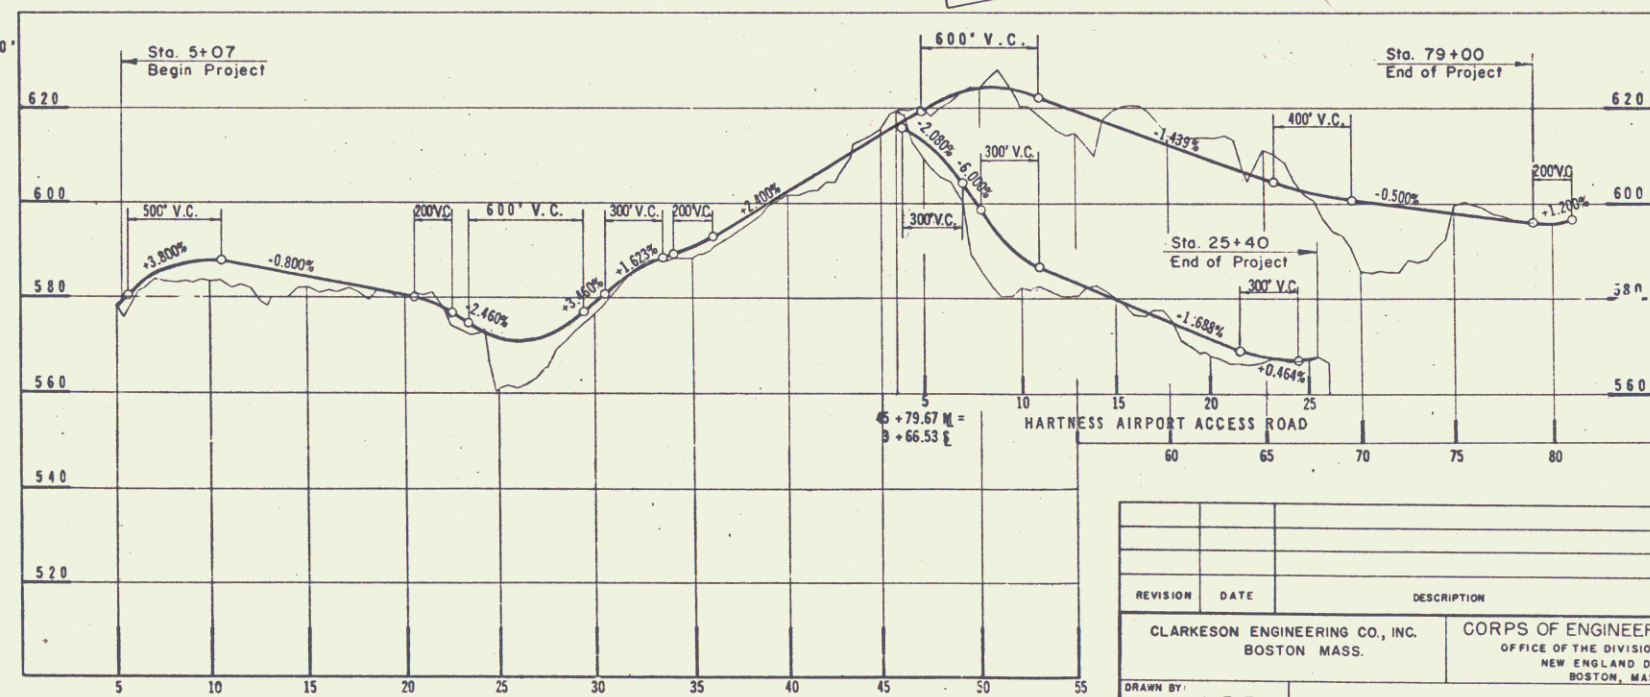


PLAN
SCALE: 1" = 1000'

ROUTE 106 RELOCATION, WEATHERSFIELD

SCALE: Hor. 1" = 300'
Vert. 1" = 20'

ROUTE 106 RELOCATION, SPRINGFIELD-WEATHERSFIELD

SCALE: Hor. 1" = 500'
Vert. 1" = 20'

REVISION	DATE	DESCRIPTION	BY

CLARKESON ENGINEERING CO., INC. BOSTON, MASS.	CORPS OF ENGINEERS U.S. ARMY OFFICE OF THE DIVISION ENGINEER NEW ENGLAND DIVISION BOSTON, MASS.
--	--

DRAWN BY: L.B.F. CHECKED BY: J.D. APPROVED BY: R.C.A., G.R., I.E.C. SUBMITTED BY: [Signature] APPROVED BY: [Signature] CHIEF ENGINEERING DIV. [Signature]	CONNECTICUT RIVER FLOOD CONTROL ROAD RELOCATIONS NORTH SPRINGFIELD DAM KEY PLAN AND PROFILES BLACK RIVER VERMONT DATE: JULY 1958 DRAWING NUMBER: CT-1-4454 SHEET: 2 OF 99
--	---