




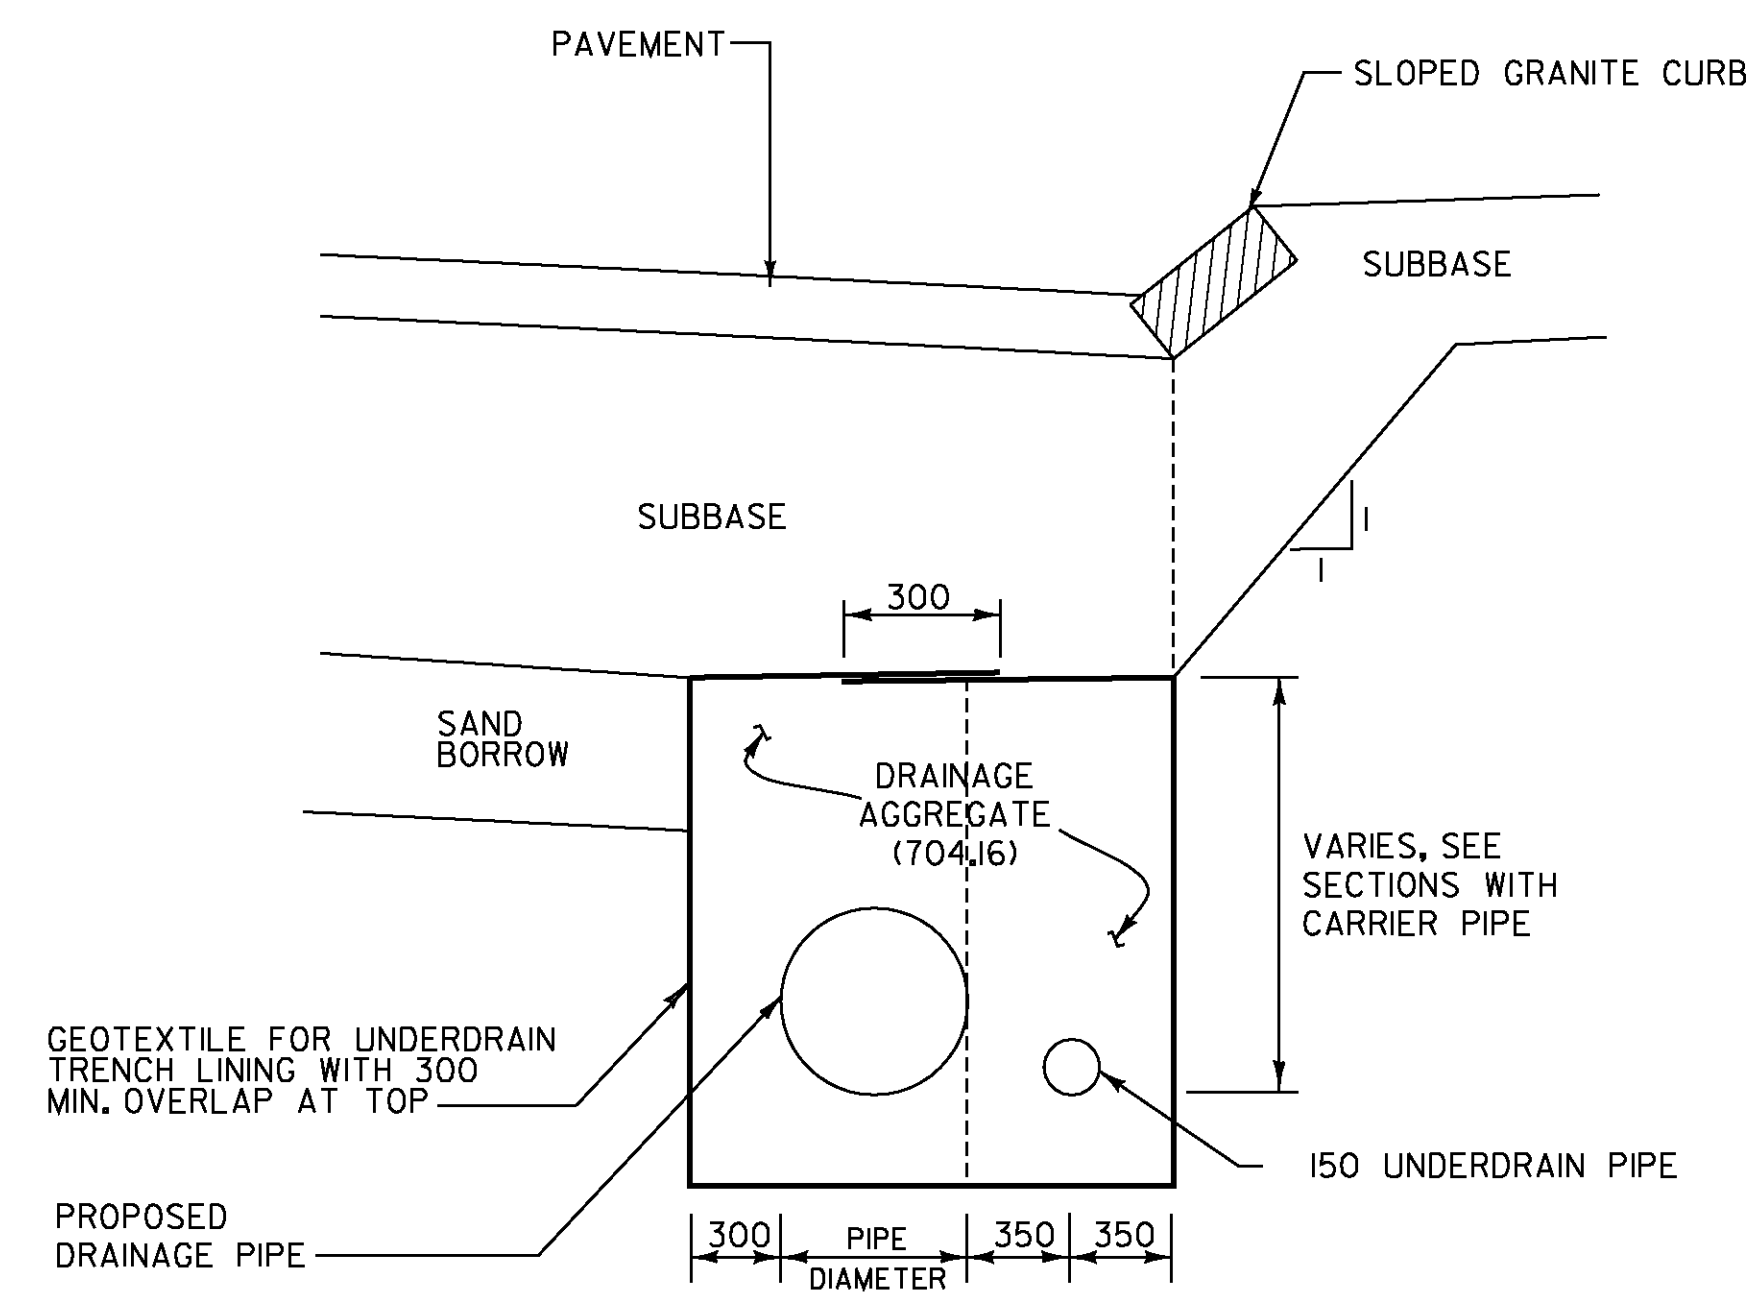

UNDERDRAIN WITH DRAINAGE PIPE *
NOT TO SCALE

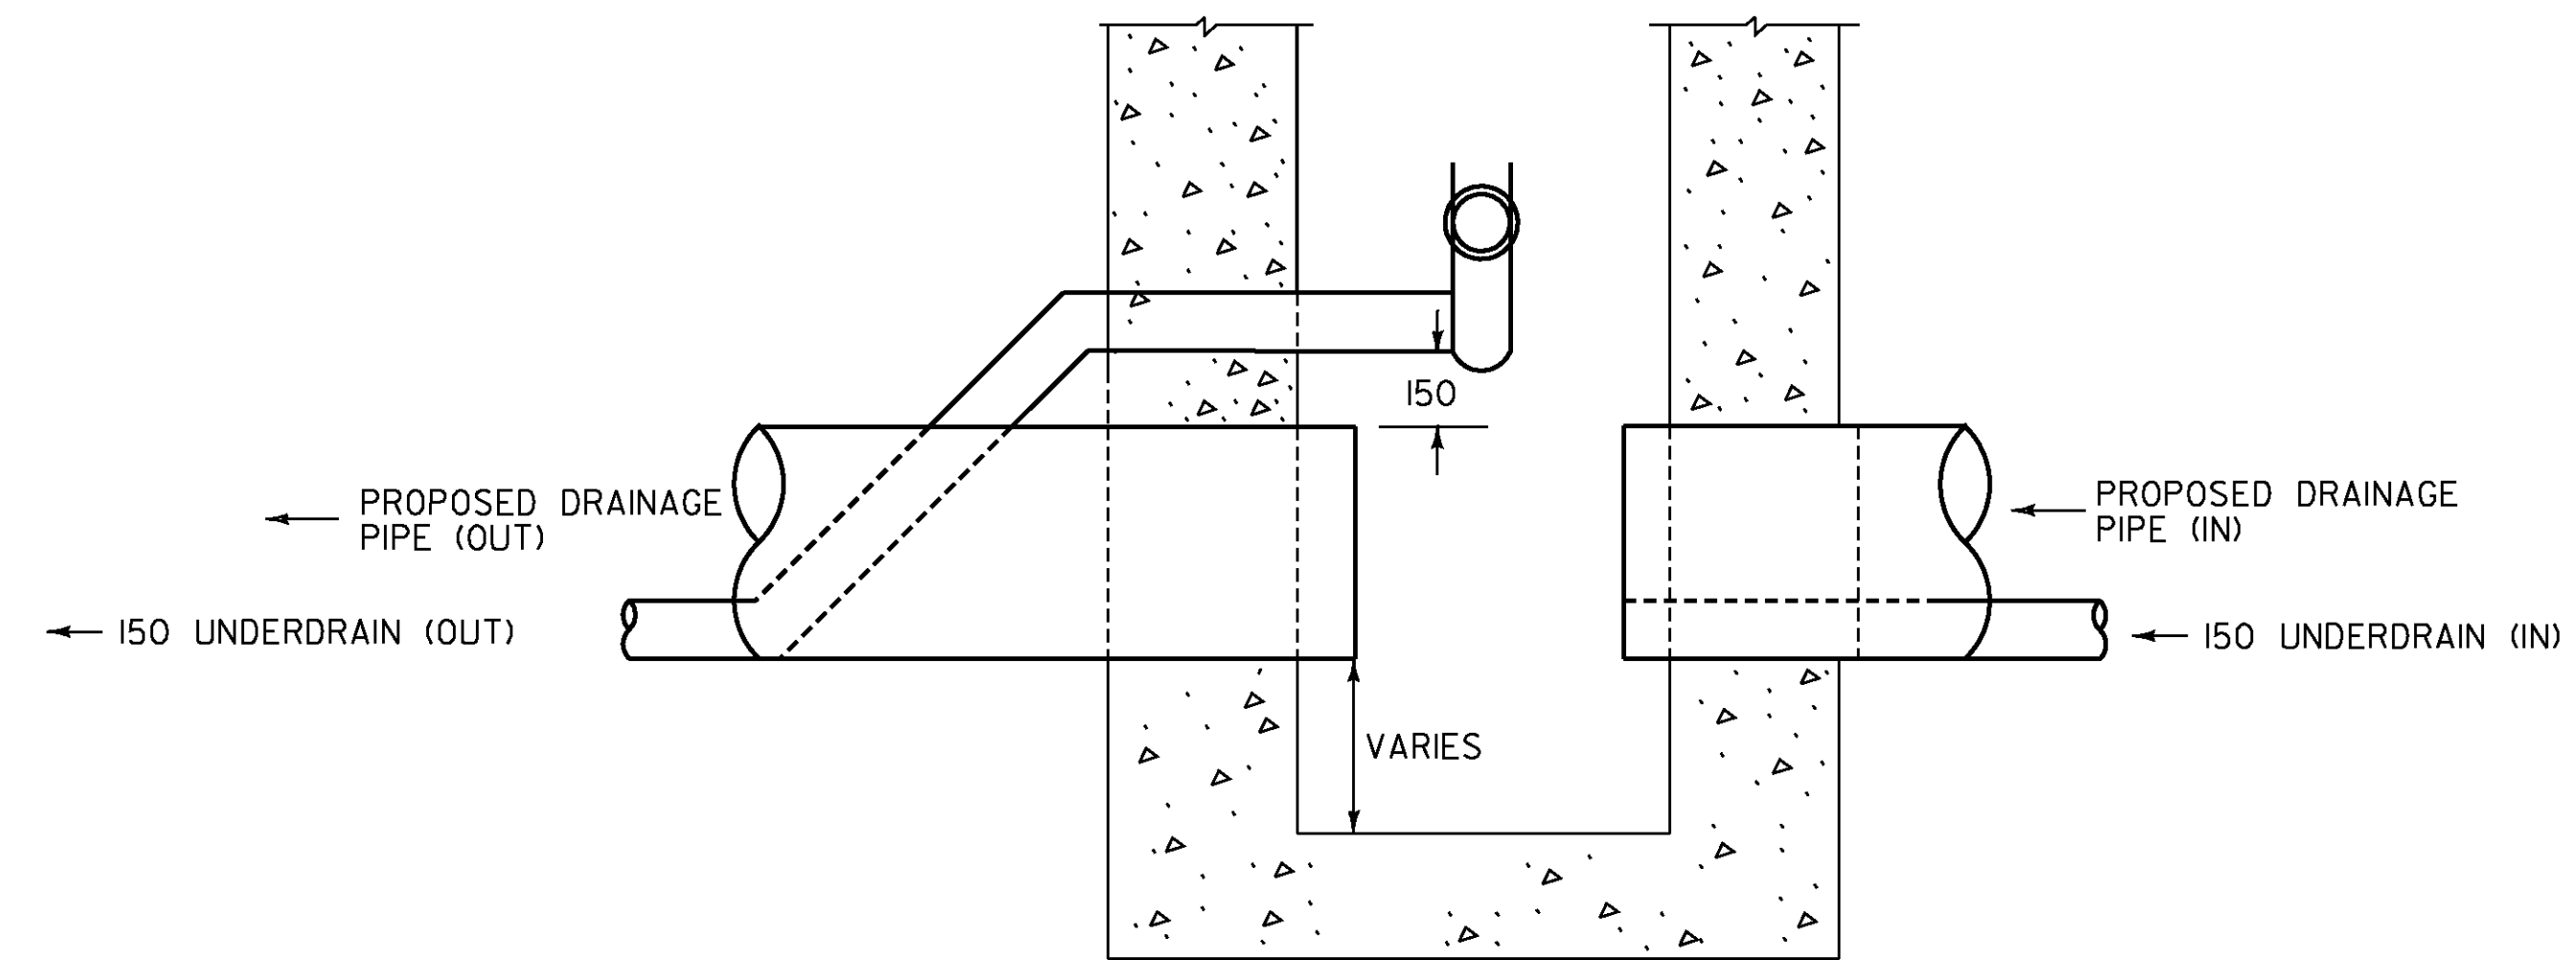

SECTION A-A

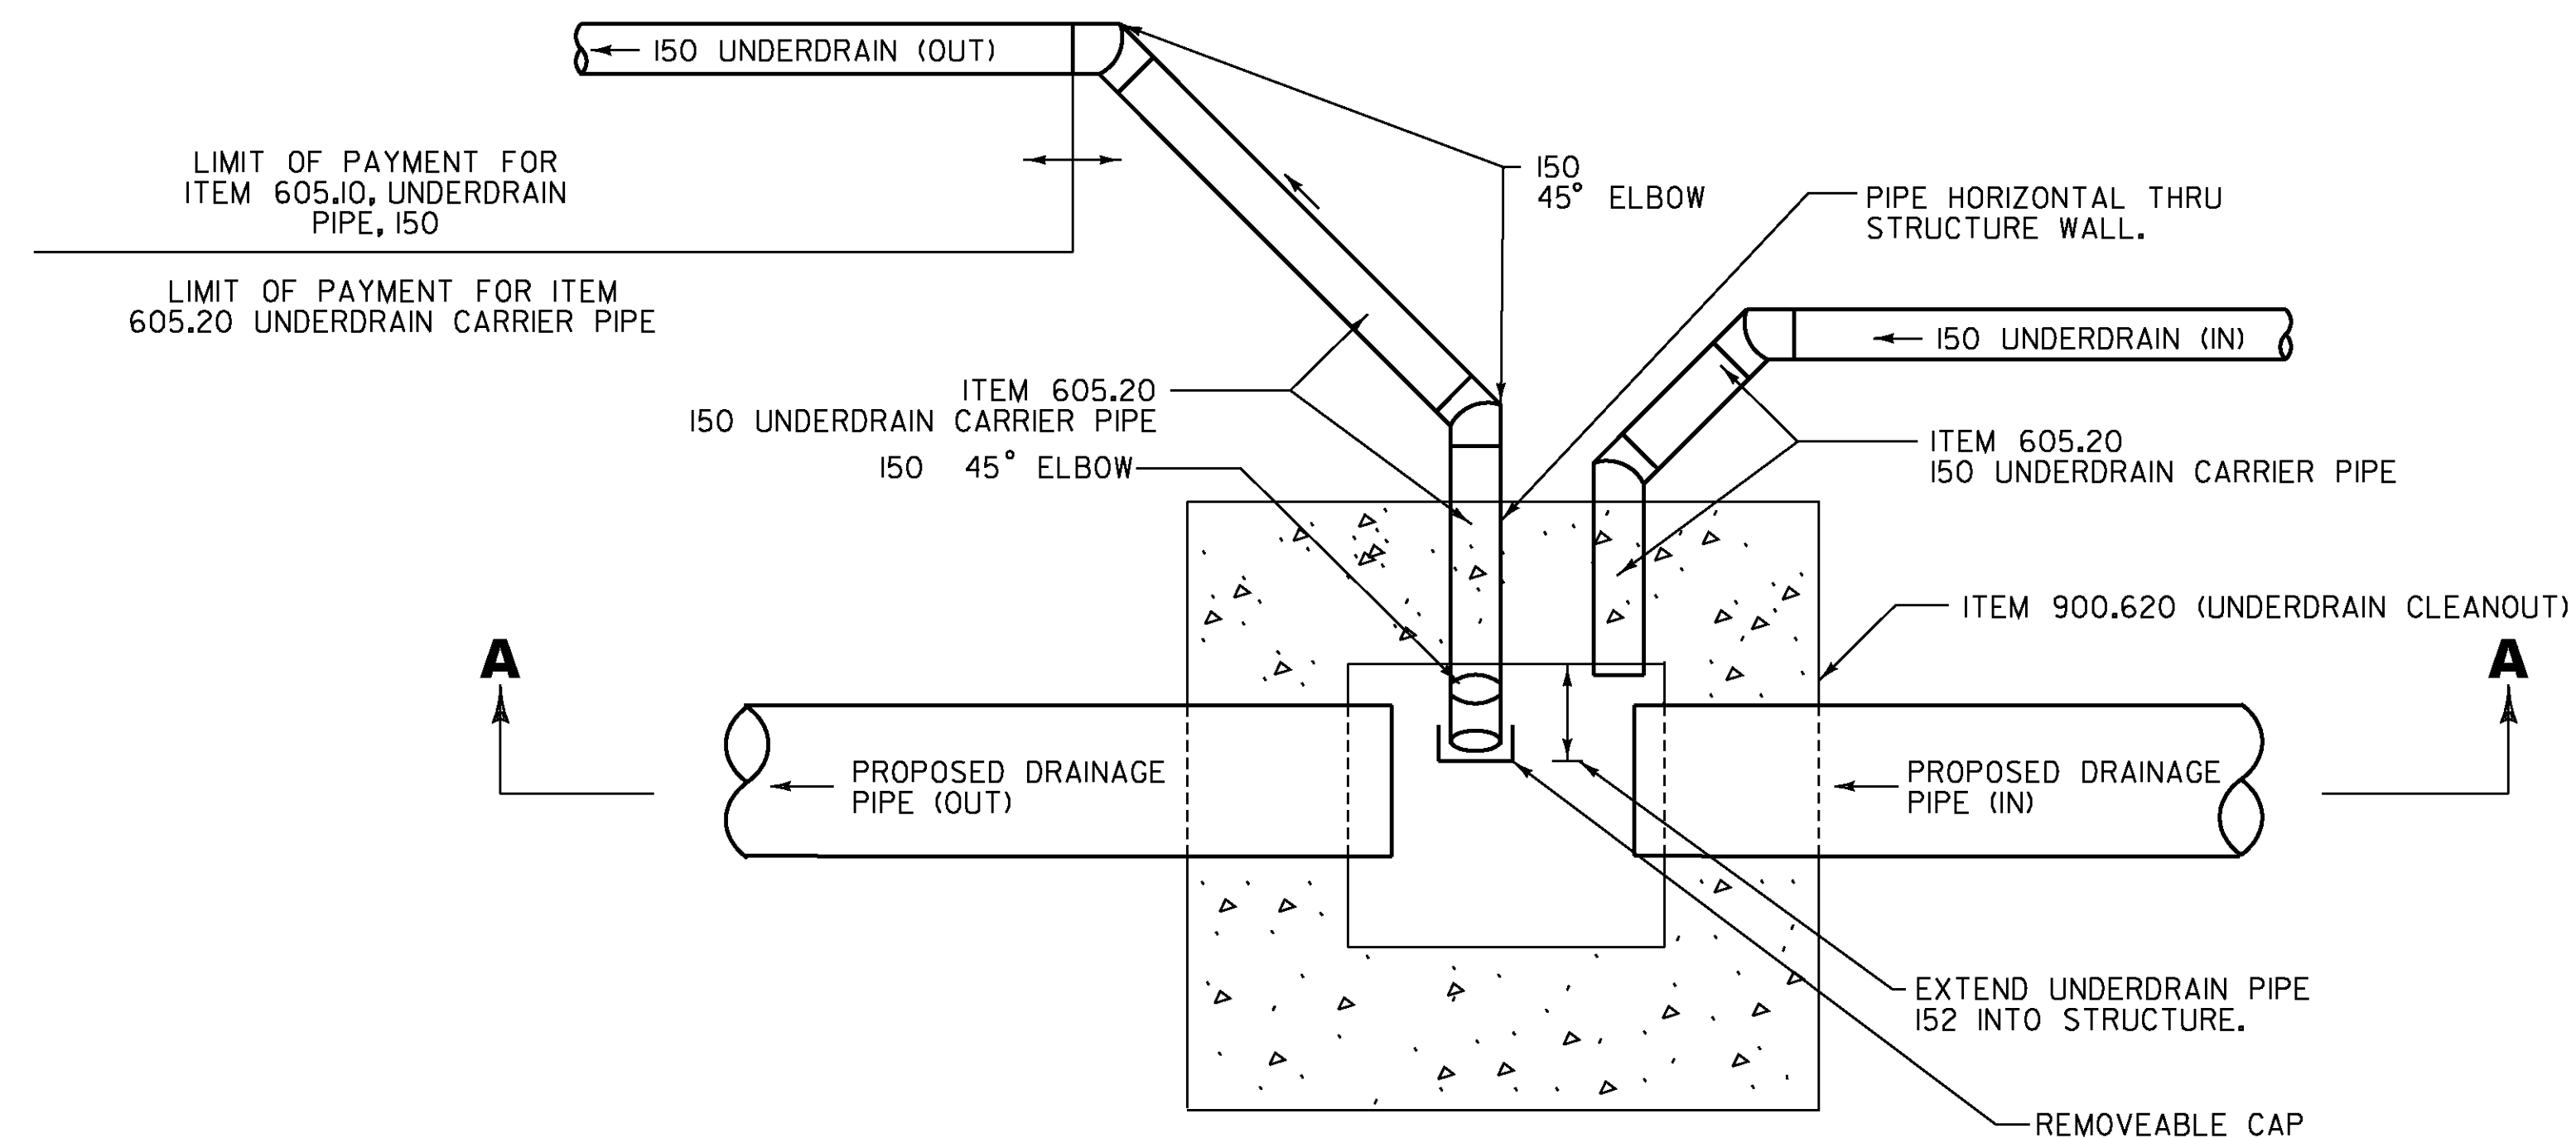

PLAN

**UNDERDRAIN CLEANOUT DETAIL
(IN DRAINAGE STRUCTURES)**

NOT TO SCALE

NOTE: ALL DIMENSIONS ARE IN MILLIMETERS (mm) EXCEPT WHERE NOTED.

*
FOR EXACT LOCATION OF DRAINAGE PIPE OR UNDERDRAIN WITH OR WITHOUT DRAINAGE PIPE, SEE DRAINAGE PLAN SHEETS AND CROSS SECTIONS. IN ACCORDANCE WITH SUBSECTION 605.06, PAYMENT FOR DRAINAGE AGGREGATE AND GEOTEXTILE IS INCLUDED IN THE COST FOR ITEM 605.10.

VERMONT AGENCY OF TRANSPORTATION



PROJECT NAME: BENNINGTON
PROJECT NUMBER: AC NH 019-1(53)

FILE NAME: ...\\plot_files\\zd307c3det.drn.ptf PLOT DATE: 5/16/2011
DESIGN SUPERVISOR: GREG EDWARDS DRAWN BY: STANTEC
DESIGNED BY: MARC FOISY CHECKED BY: GARY SANTY
DRAINAGE DETAILS DD- 1 SHEET 110 OF 577