

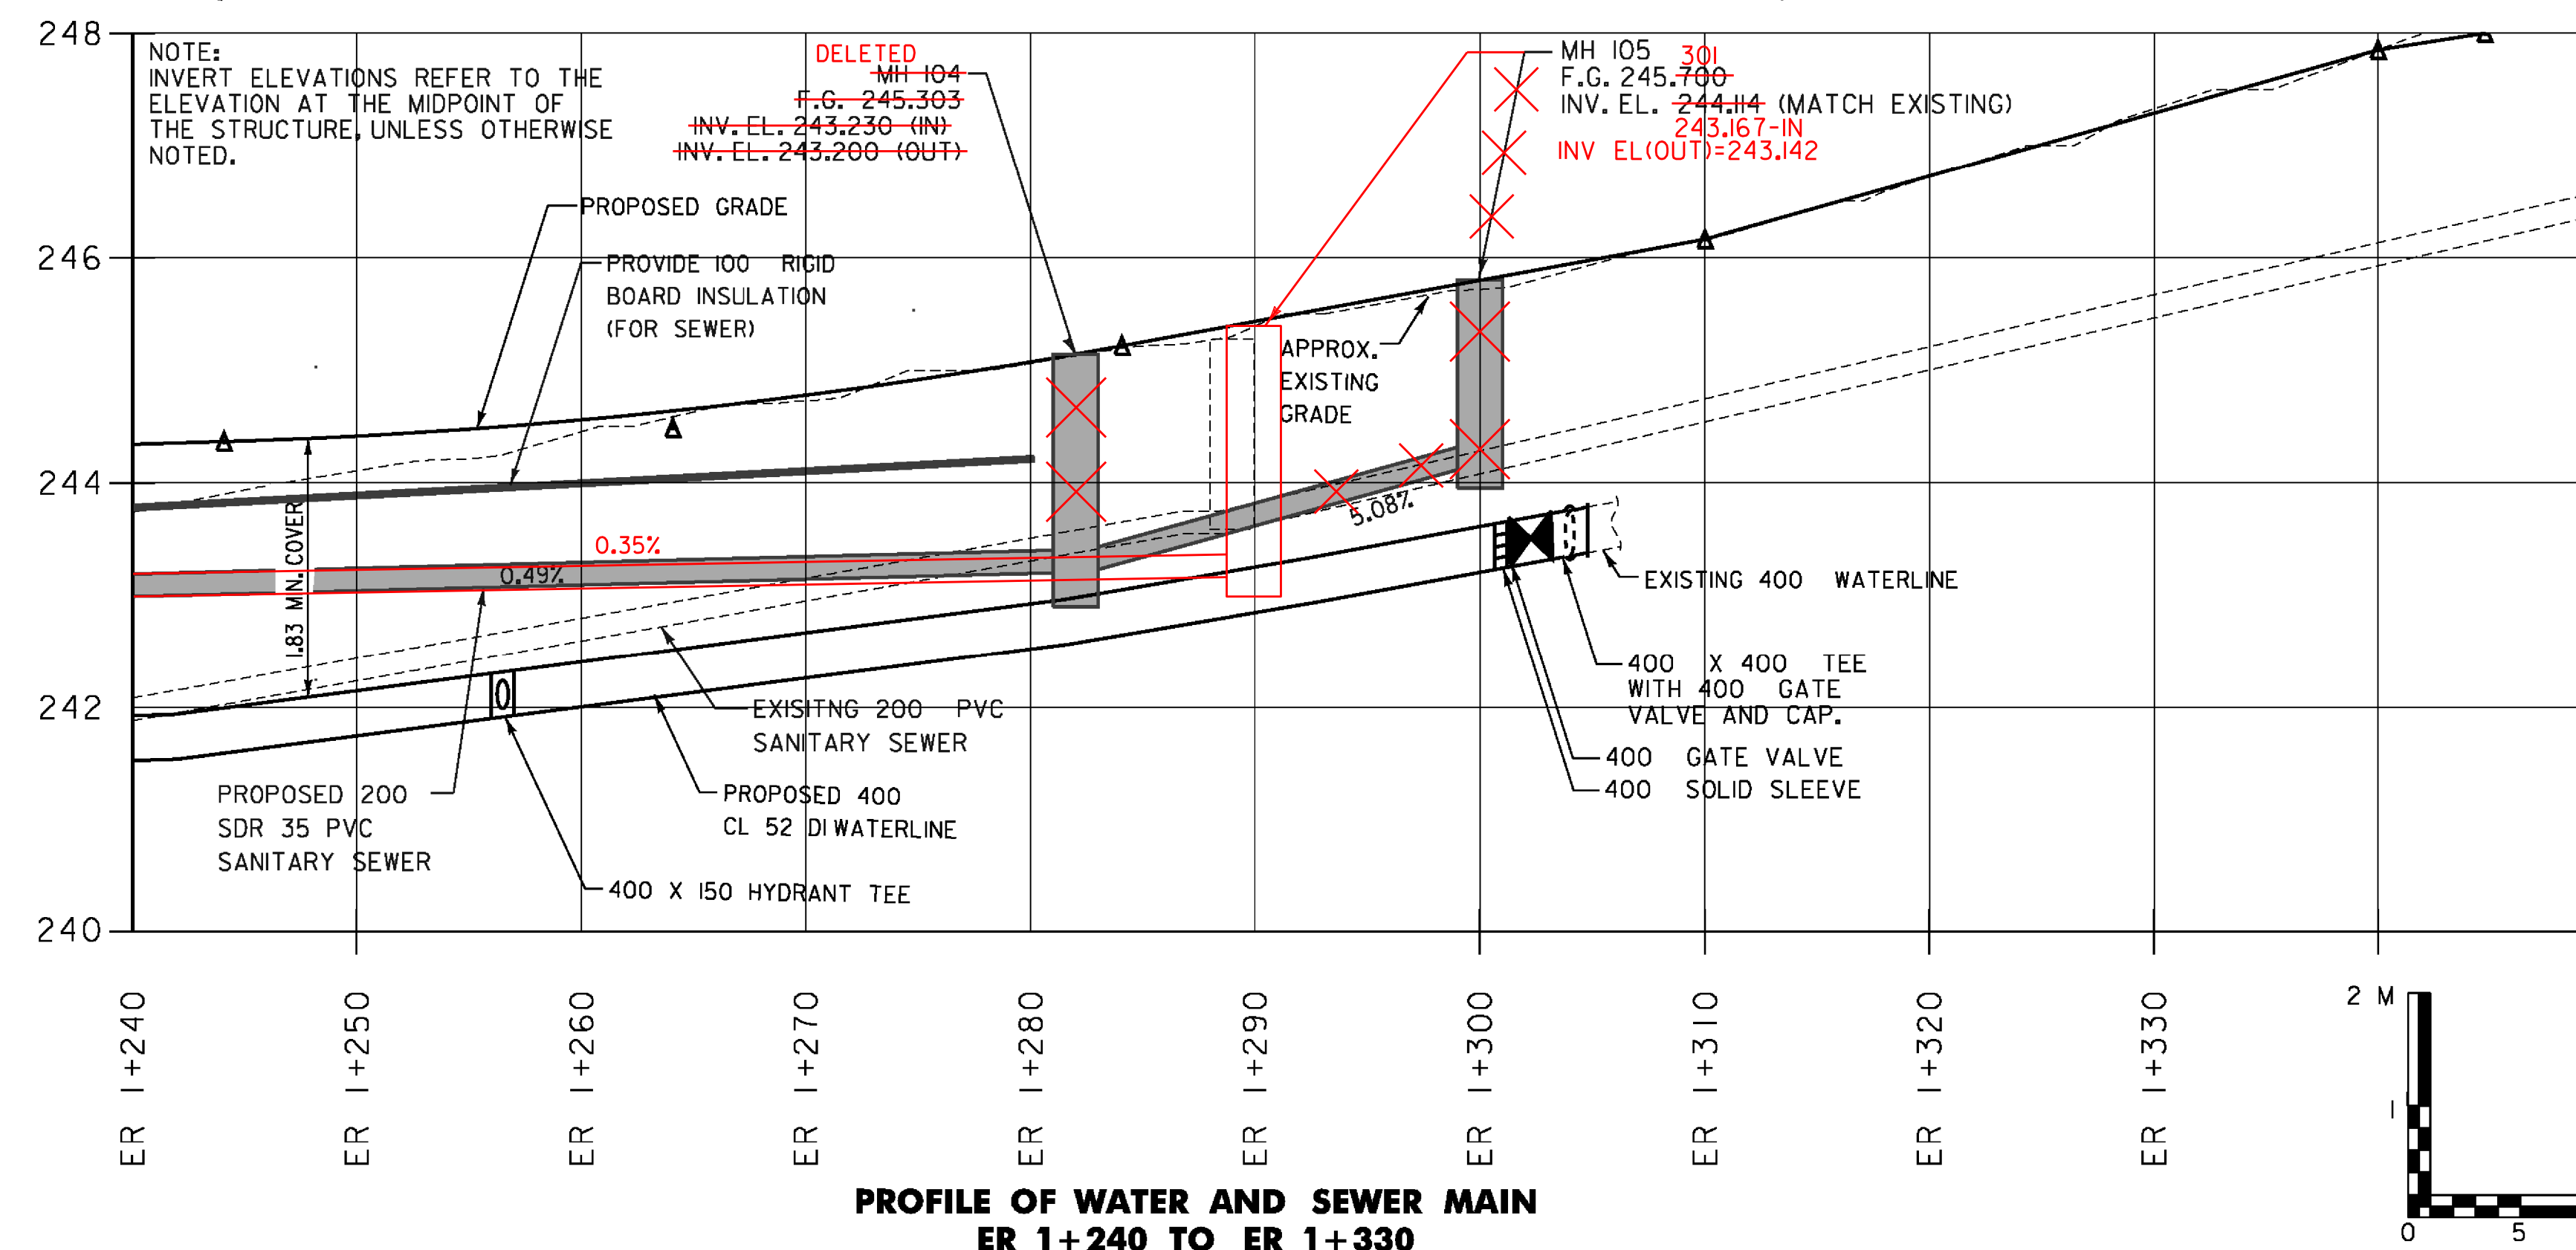


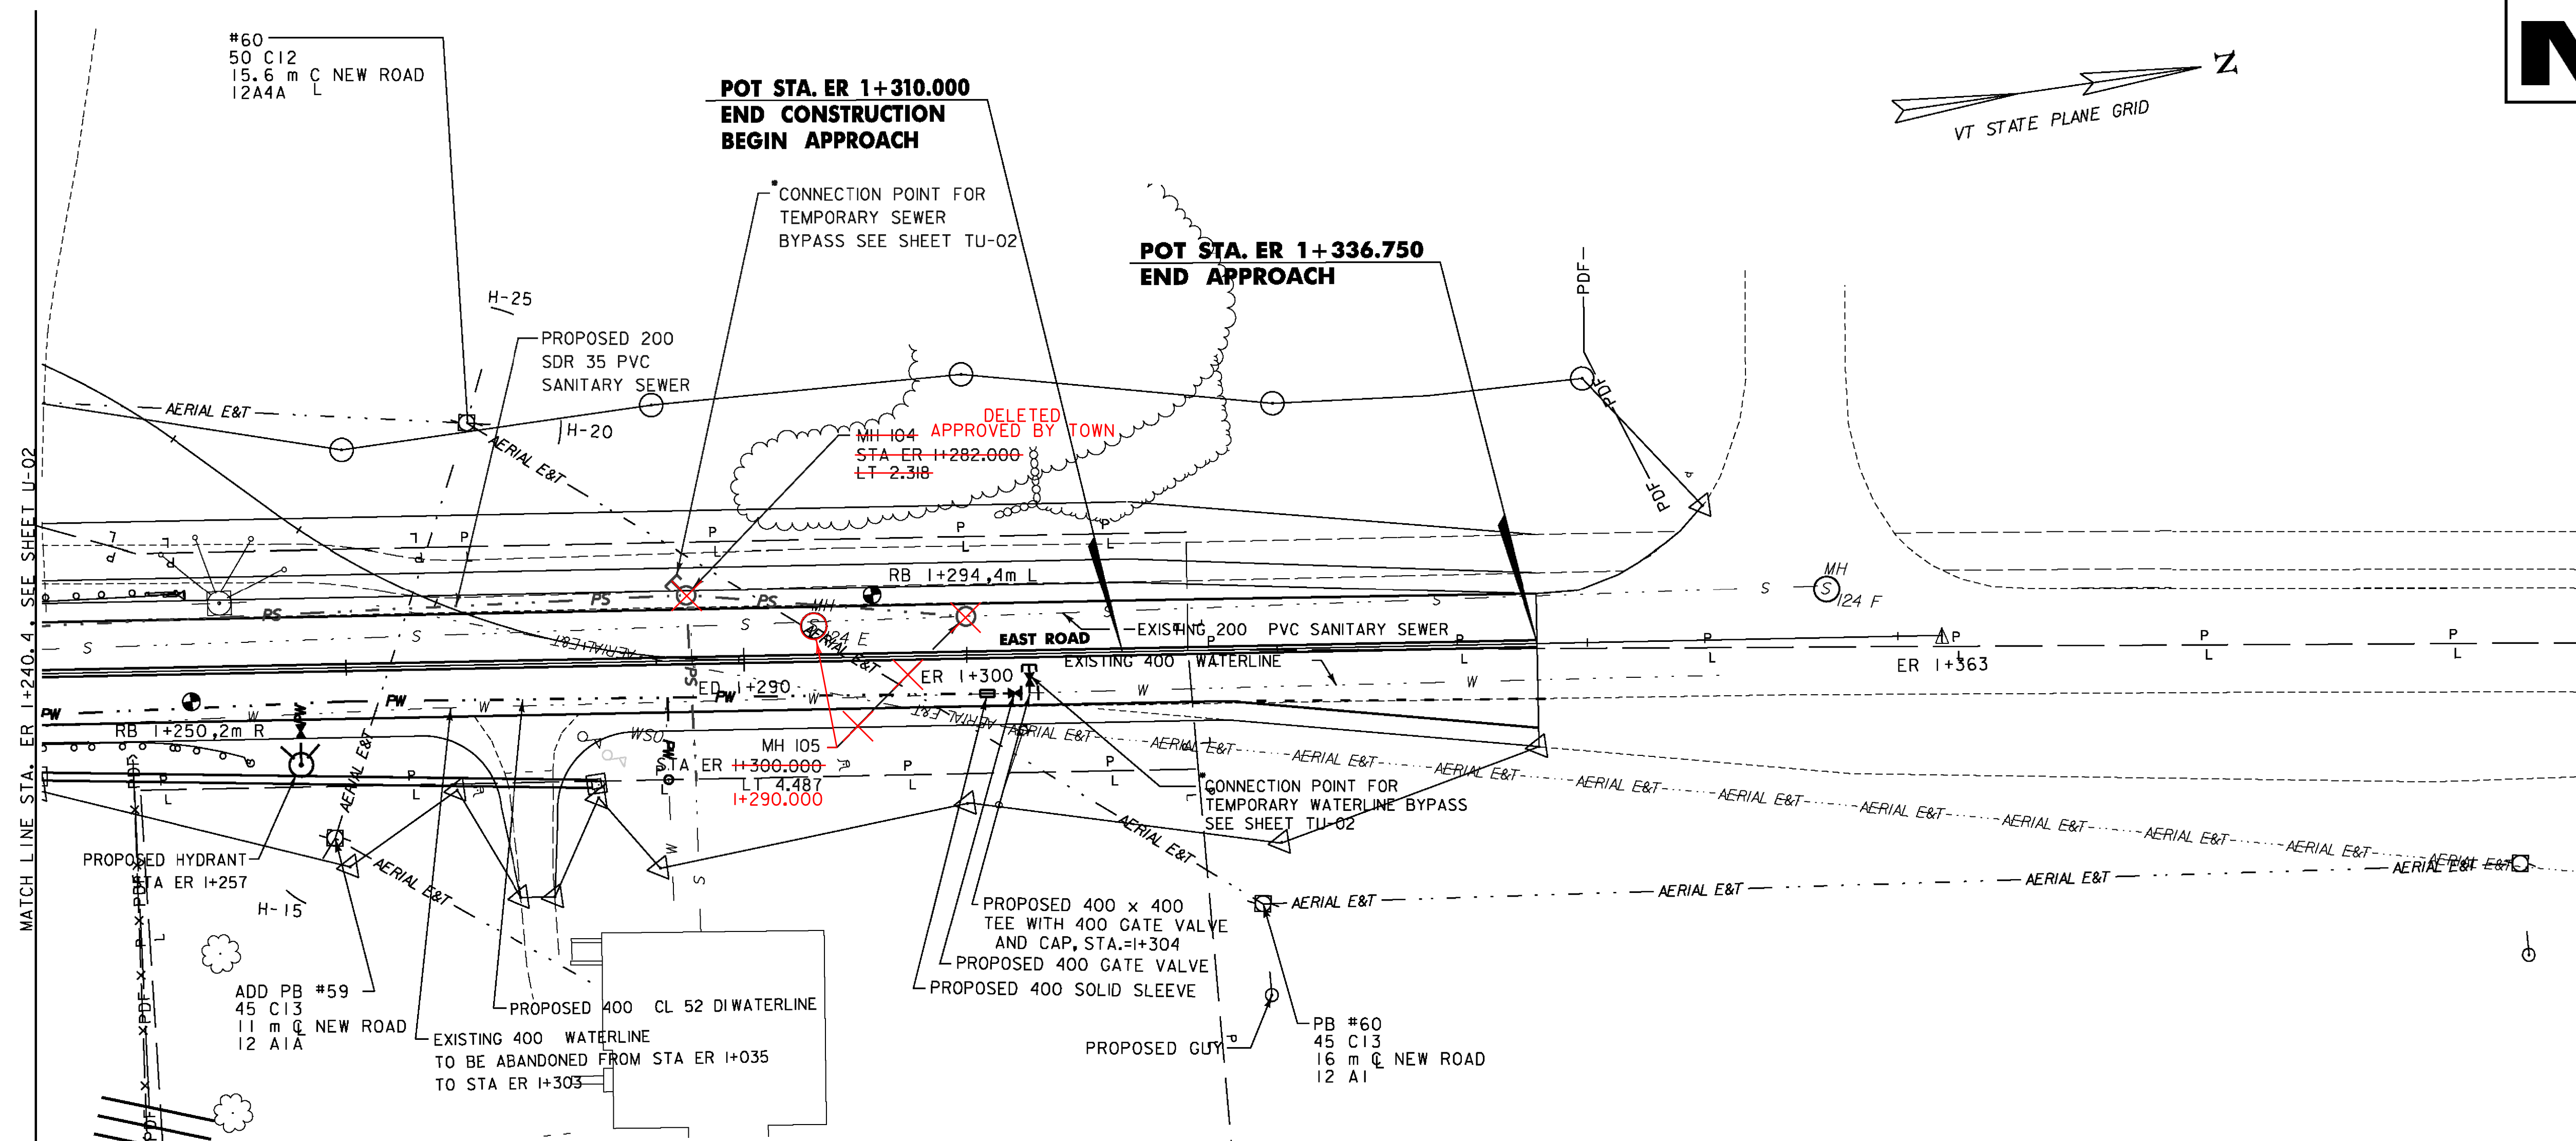

LEGEND

TEMPORARY WATER	=====
TEMPORARY SEWER	=====
PERMANENT WATER	— PW —
PERMANENT SEWER	— PS —
EXISTING WATER	— W —
EXISTING SEWER	— S —

***NOTE:**
FOR MORE INFORMATION ON TEMPORARY UTILITY CONNECTIONS SEE SHEETS TC-01 THRU TC-03

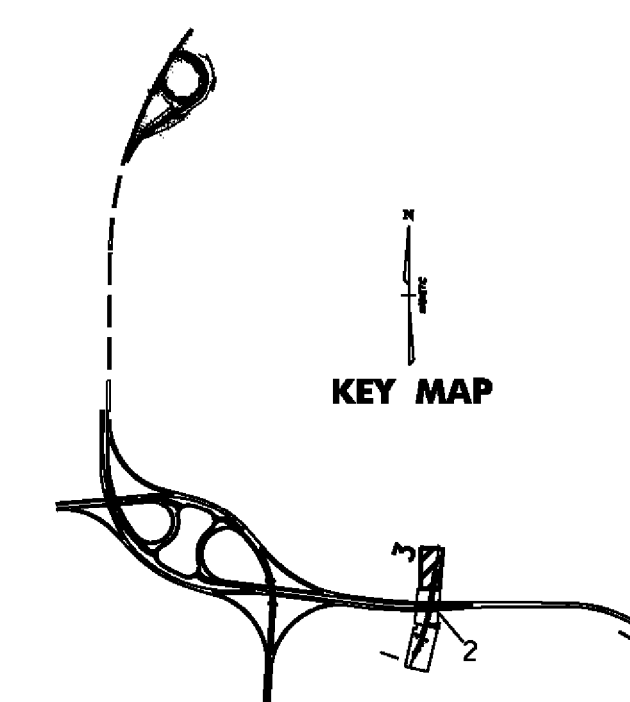

NOTE: ALL DIMENSIONS ARE IN MILLIMETERS (mm) EXCEPT WHERE NOTED.

VERMONT AGENCY OF TRANSPORTATION



PROJECT NAME: BENNINGTON
PROJECT NUMBER: AC NH 019-(K53)

FILE NAME: ...\\plot_files\\zd307c3utl4.ptf PLOT DATE: 5/25/2011
DESIGN SUPERVISOR: GREG EDWARDS DRAWN BY: STANTEC
DESIGNED BY: T. KNIGHT CHECKED BY: M. CHENETTE
UTILITY PLAN U-04 SHEET 158 OF 577