


WIRED CONDUIT (50mm) (PVC)
WB 9+880.0, 7.0m RT. - WB 9+920.0, 7.8m RT.
WB 9+920.0, 7.8m RT. - WB 9+980.0, 7.8m RT.
WB 9+980.0, 7.8m RT. - WB 10+021.4, 7.0m RT.
WB 10+021.4, 7.0m RT. - NB 10+020.0, 7.0m RT.
WB 10+021.4, 7.0m RT. - WB 10+040.0, 7.8m RT.
WB 10+040.0, 7.8m RT. - WB 10+059.0, 9.3m RT.
WB 10+059.0, 9.3m RT. - WB 10+100.0, 8.1m RT.
WB 10+100.0, 8.1m RT. - WB 10+160.0, 8.1m RT.
WB 10+160.0, 8.1m RT. - WB 10+210.0, 7.6m RT.
F 1+830.0, 2.8m RT. - F 1+880.0, 3.6m RT.
NB 9+970.0, 12.1m LT. - NB 9+980.0, 13.4m LT.
NB 9+970.0, 12.3m LT. - NB 10+021.4, 7.0m LT.
NB 9+980.0, 13.4m LT. - NB 10+021.4, 7.0m LT.
NB 10+020.0, 7.0m RT. - NB 10+021.4, 7.0m LT.
NB 10+020.0, 7.0m RT. - NB 10+025.0, 7.8m RT.
NB 10+020.0, 7.0m RT. - WB 10+021.4, 7.0m RT.
NB 10+021.0, 13.0m LT. - NB 10+040.0, 13.8m LT.
NB 10+040.0, 13.8m LT. - NB 10+090.0, 13.8m LT.
NB 10+090.0, 13.8m LT. - F 1+880.0, 2.8m RT.

**ELECTRICAL CONDUIT SLEEVE
(200mm) (PVC) (SCH 80)**

WB 10+021.2, 1.4m LT. - WB 10+021.4, 6.2m RT.
NB 10+020.9, 5.9m RT. - NB 10+021.3, 12.2m LT.

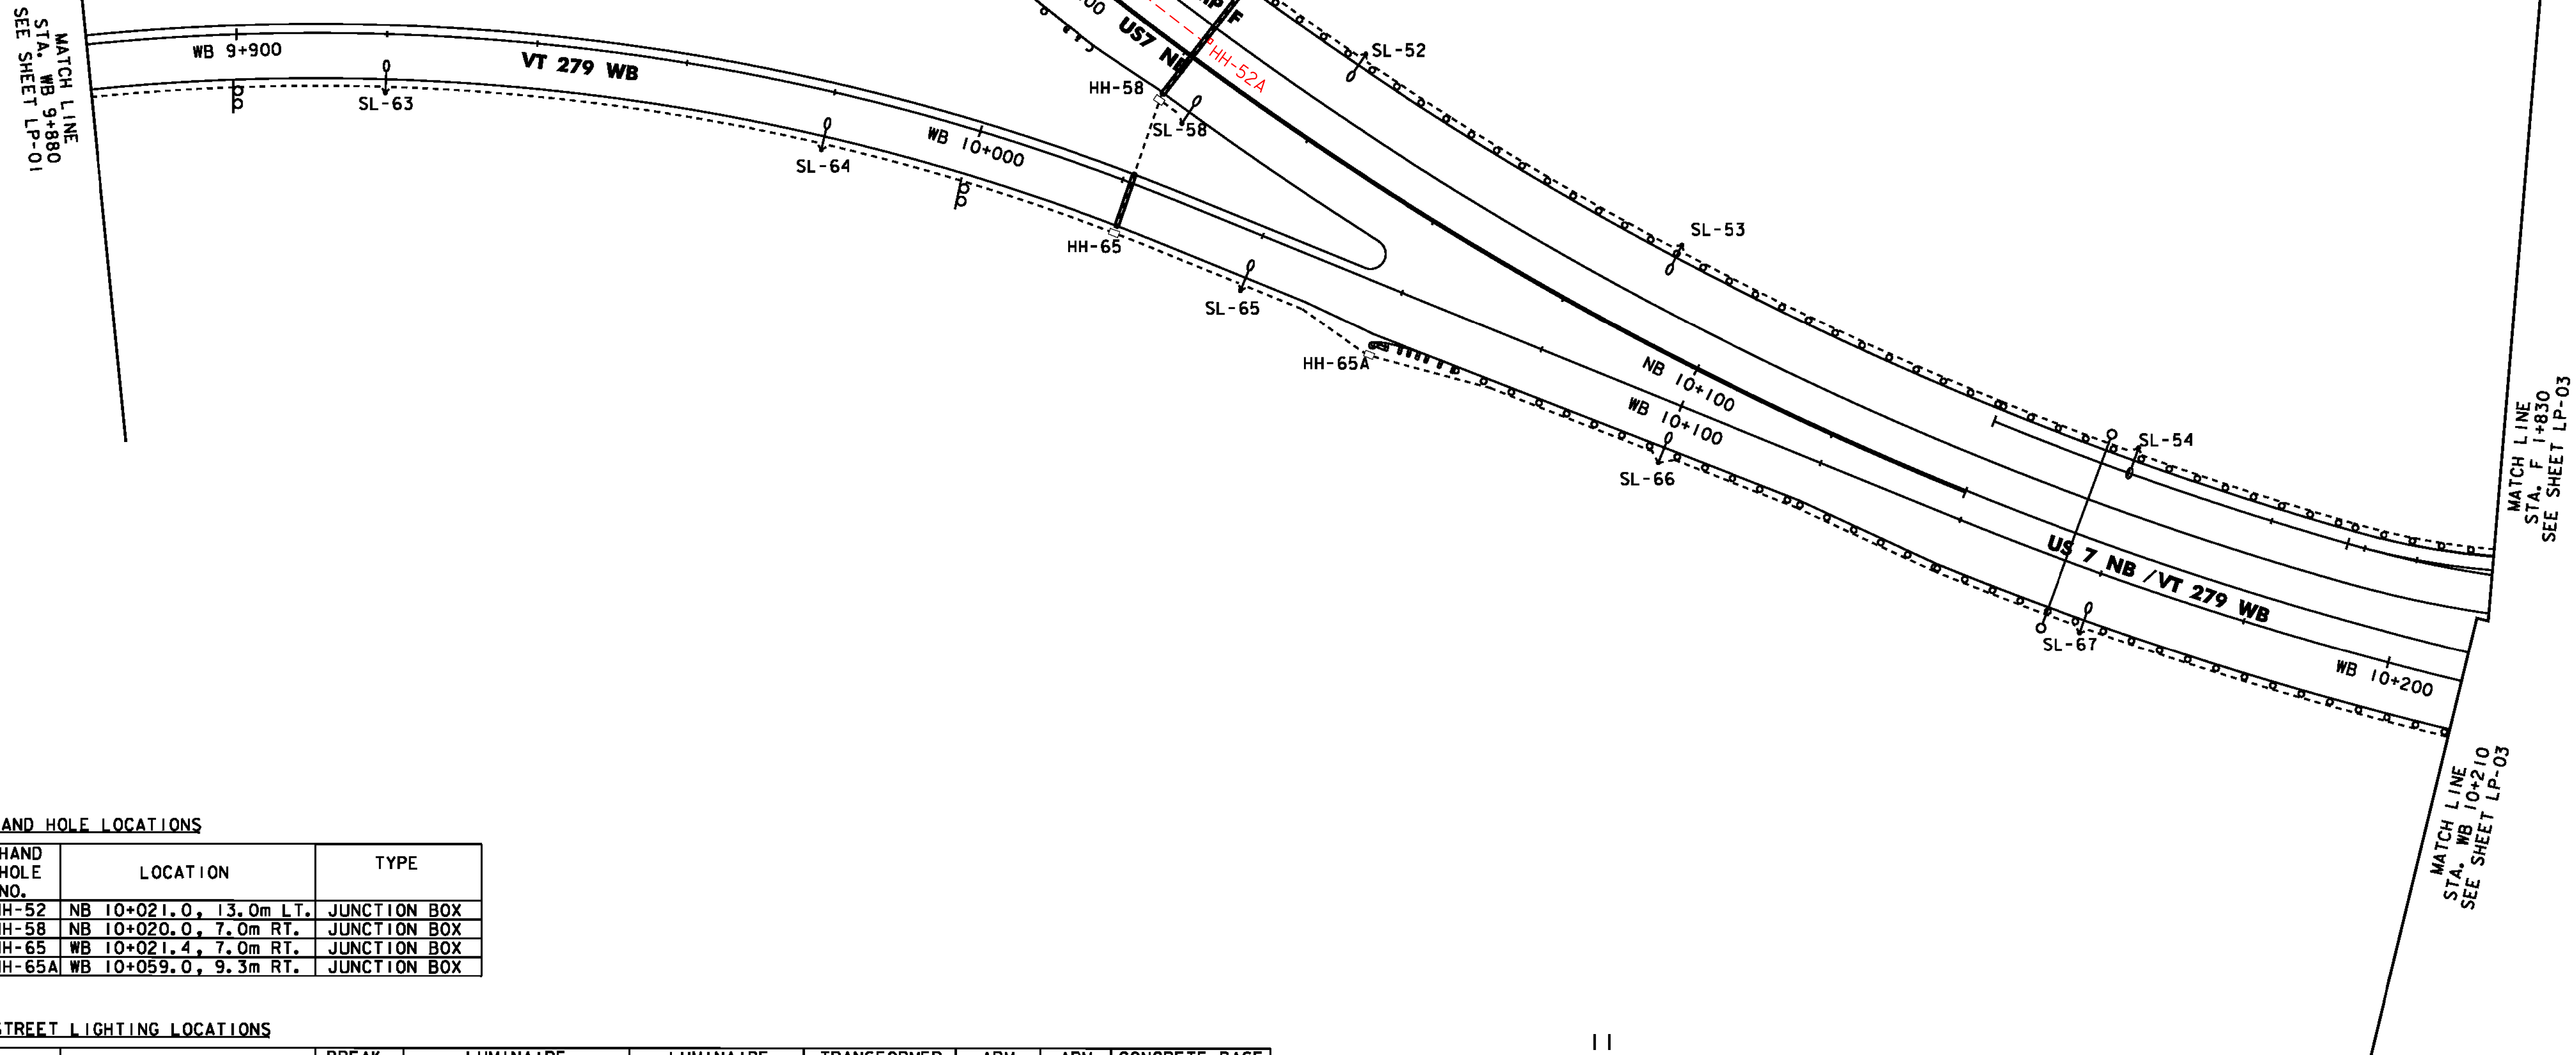


HAND HOLE LOCATIONS

HAND HOLE NO.	LOCATION	TYPE
HH-52	NB 10+021.0, 13.0m LT.	JUNCTION BOX
HH-58	NB 10+020.0, 7.0m RT.	JUNCTION BOX
HH-65	WB 10+021.4, 7.0m RT.	JUNCTION BOX
HH-65A	WB 10+059.0, 9.3m RT.	JUNCTION BOX

STREET LIGHTING LOCATIONS

POLE NO.	LOCATION	BREAK-AWAY BASE	LUMINAIRE			LUMINAIRE MOUNTING HT. TO ROADWAY (M)	TRANSFORMER BASE HT. (M)	ARM RISE (M)	ARM LENGTH (M)	CONCRETE BASE DIAM / DEPTH (mm) / (mm)
			WATTS	DIST. TYPE	VOLTAGE					
SL-51	NB 9+980.0, 13.4m LT.	NO	200	III	240	10.600	0.500	0.762	0.610	610/1828
SL-52	NB 10+040.0, 13.8m LT.	NO	200	III	240	10.600	0.500	0.762	0.610	610/1828
SL-53	NB 10+090.0, 13.8m LT.	NO	200	III	240	10.600	0.500	0.762	0.610	610/1828
SL-54	F 1+880.0, 3.6m RT.	NO	200	III	240	10.600	0.500	0.762	0.610	610/1828
SL-58	NB 10+025.0, 7.8m RT.	YES	200	III	240	10.600	0.500	0.762	0.610	610/1828
SL-63	WB 9+920.0, 7.8m RT.	YES	200	III	240	10.600	0.500	0.762	0.610	610/1828
SL-64	WB 9+980.0, 7.8m RT.	YES	200	III	240	10.600	0.500	0.762	0.610	610/1828
SL-65	WB 10+040.0, 7.8m RT.	YES	200	III	240	10.600	0.500	0.762	0.610	610/1828
SL-66	WB 10+100.0, 8.1m RT.	NO	200	III	240	10.600	0.500	0.762	0.610	610/1828
SL-67	WB 10+160.0, 8.1m RT.	NO	200	III	240	10.600	0.500	0.762	0.610	610/1828

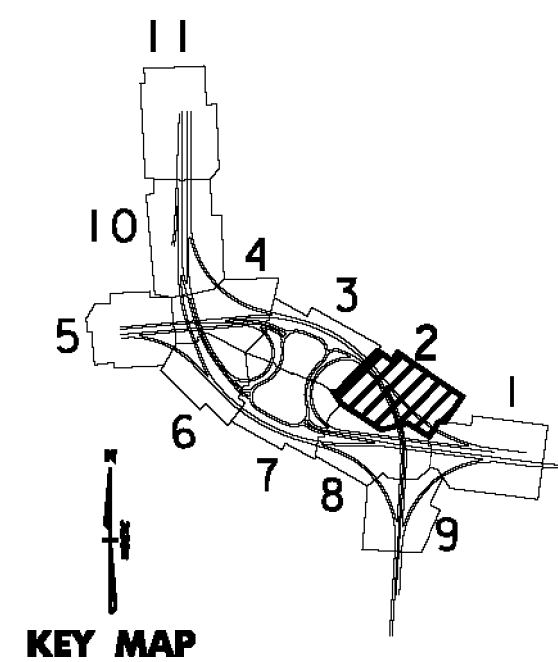

1:500 SCALE
FULL SIZE



PROJECT NAME: BENNINGTON
PROJECT NUMBER: NH 019-1(54)

FILE NAME: ...z307c4lgt.plans.ptf
DESIGN SUPERVISOR: GREG EDWARDS
DESIGNED BY: MAEGAN CROWLEY
LIGHTING PLANS LP-02

PLOT DATE: 3/16/2010
DRAWN BY: STANTEC
CHECKED BY: GARY SANTY
SHEET 225 OF 468