


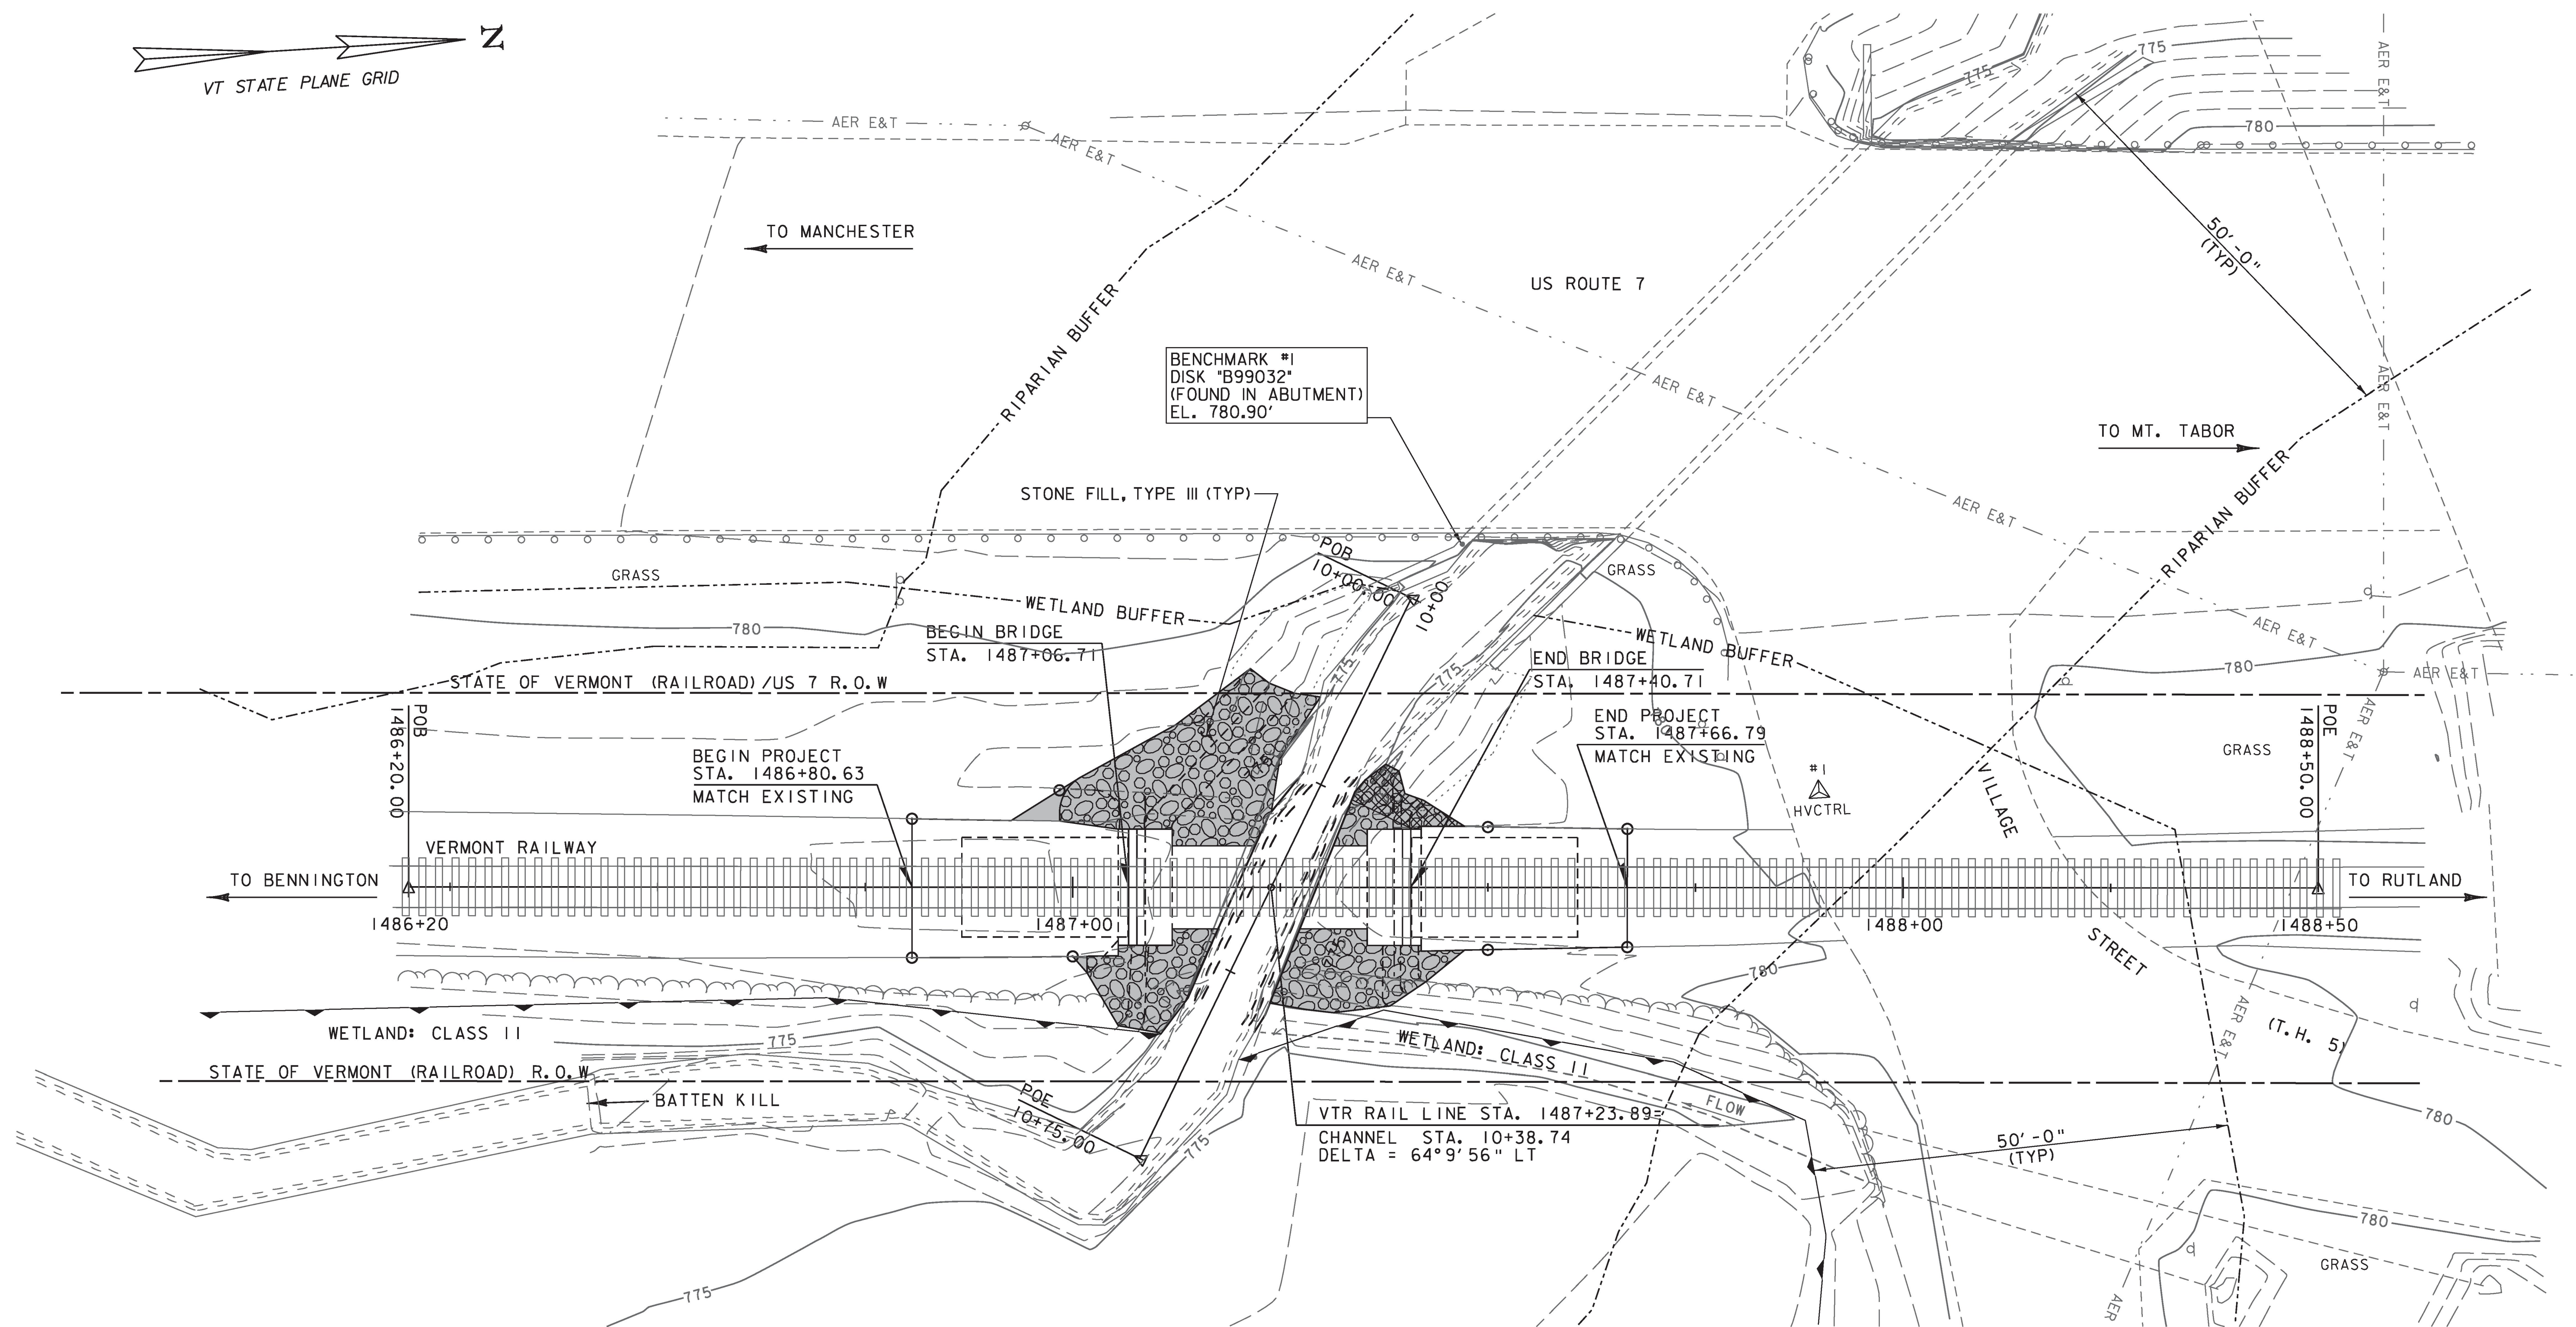

NOTE: SEE SHEET 7 FOR SYMBOLS

SCALE 1" = 10'-0"
10 0 10

VHB Vanasse Hangen Brustlin, Inc.

PROJECT NAME: DORSET
PROJECT NUMBER: WCRS(8)

FILE NAME: z08g224bdr nul.dgn
PROJECT LEADER: A.P. GUYETTE
DESIGNED BY: E.A. FIALA
EPSC FINAL CONDITIONS SITE PLAN

PLOT DATE: 5/2/2014
DRAWN BY: E.A. FIALA
CHECKED BY: B.O. CRONIN
SHEET 31 OF 33

VHB 57320