


State of Vermont
Department of Buildings & General Services
William Morse State Airport
NEW ENTRY CANOPY
AND RENOVATIONS
Bennington, Vermont

AGENCY OF ADMINISTRATION
DEPT. OF BUILDINGS & GENERAL SERVICES
2 GOVERNOR AIKEN AVENUE
MONTPELIER, VERMONT 05633-5801
THOMAS W. TORTI, COMMISSIONER

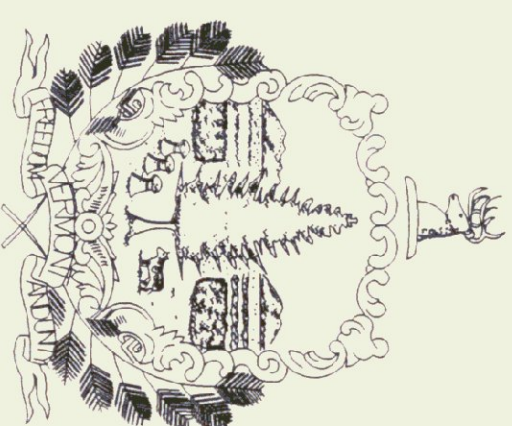

Howard Dean, M.D.
Governor


March 14, 2000

INDEX OF SHEETS



A-1 Plans & Details
A-2 Elevations, Details, Electrical

Jon A. Traver Associates, Architect
PO Box 488 13 Bank Street
North Bennington, Vermont 05257
PHONE: (802) 447-1174
FAX: (802) 442-4817

AGENCY OF TRANSPORTATION
NATIONAL LIFE BUILDING
DRAWN BY 333
MONTPELIER, VERMONT 05633
BRIAN SEARLES, SECRETARY

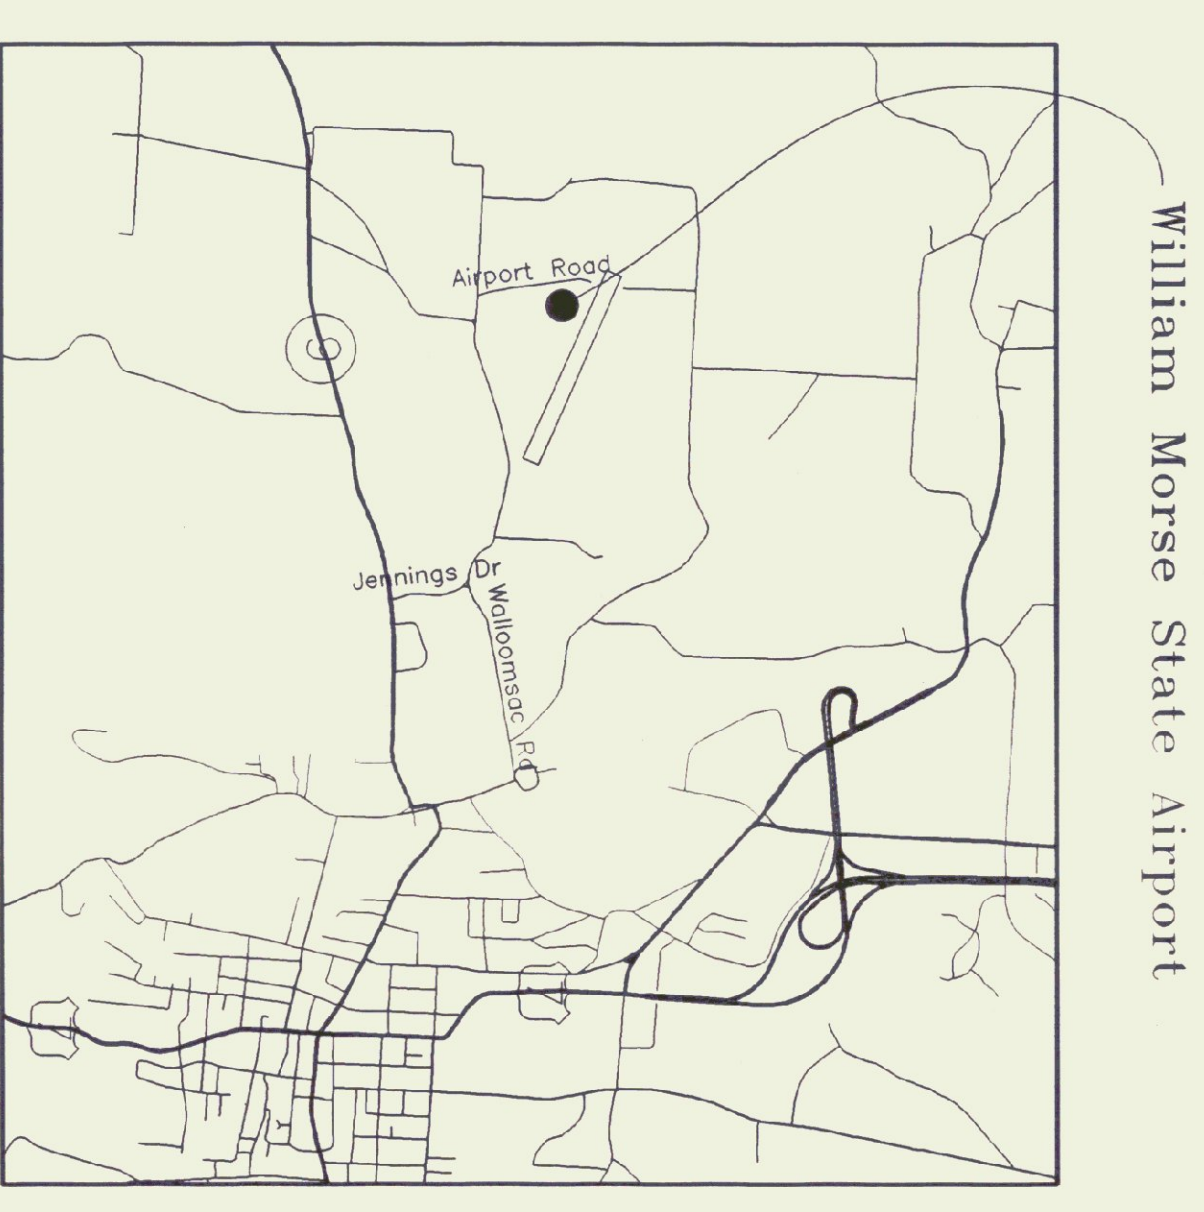









PROJECT LOCATION

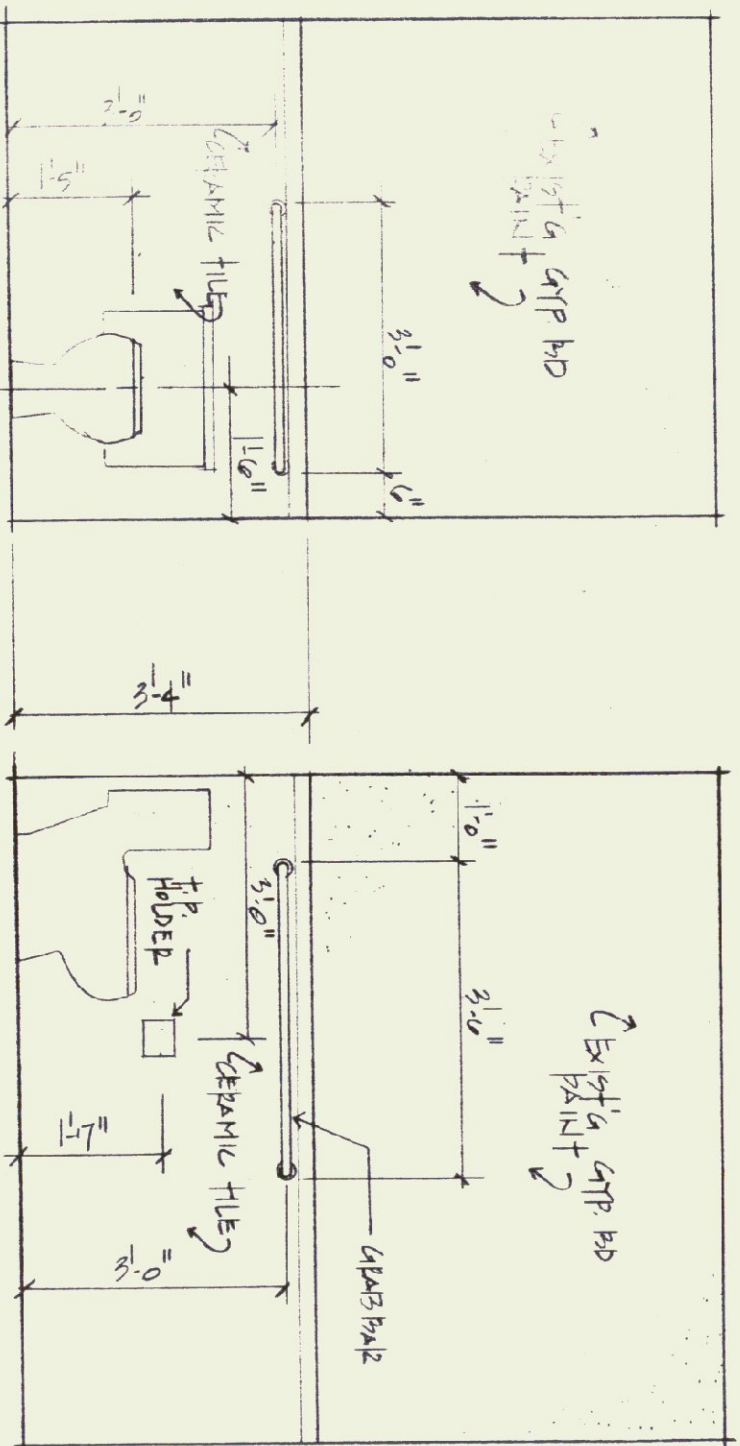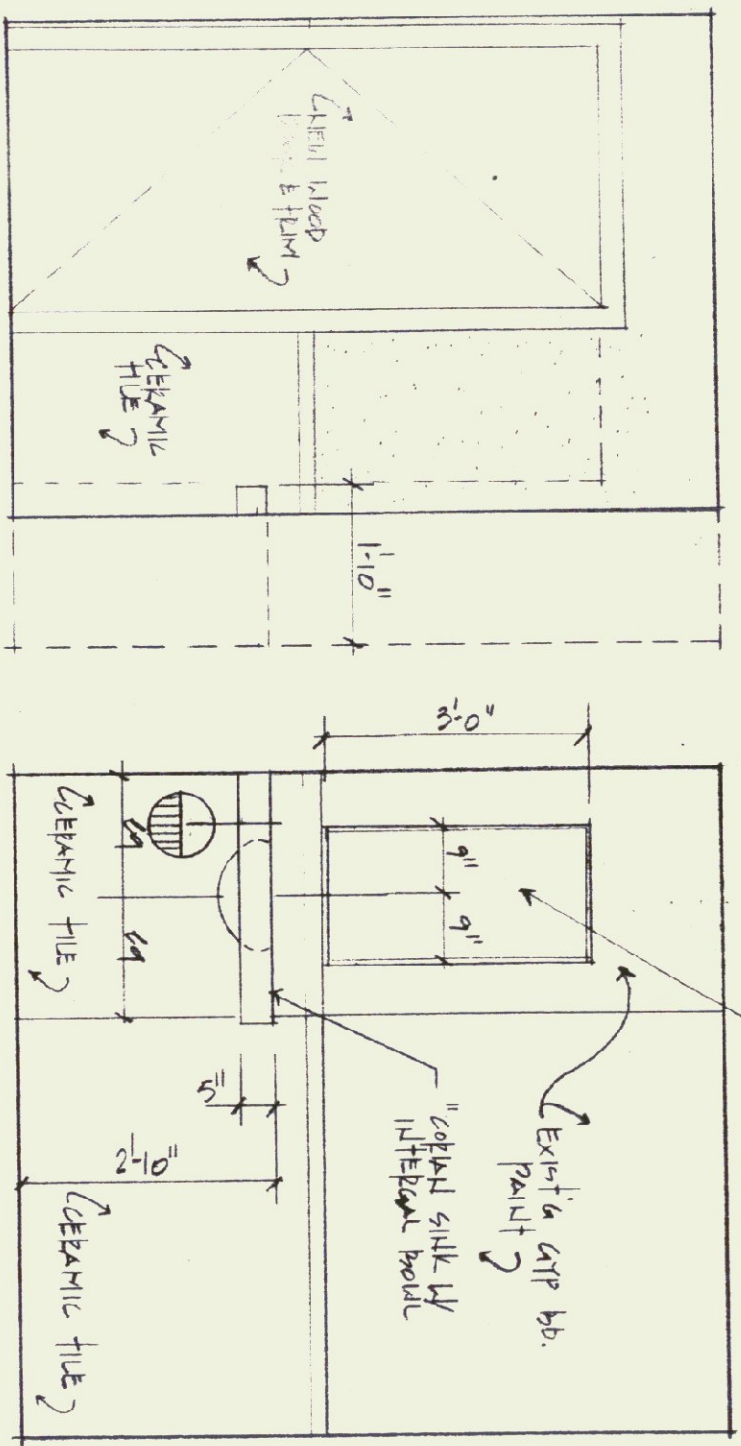


EXISTING TOILET ROOM

PLUMBING NOTES:

1. All plumbing work shall be done in accordance with Local, State, and National Plumbing Code Requirements.
2. All domestic water piping shall be insulated.
3. Provide readily accessible fixture stops for all fixtures on both hot and cold water supplies. All exposed piping, and accessories shall be chrome plated.
4. Remove existing plumbing fixtures from existing toilet room as shown. Cut existing floor and walls as required to cut back at unobstructed piping to be below finished floor or wall and cap. The new plumbing lines into existing, maintaining same size and pipe material. Run all new piping below floors or in walls to keep concealed for as long as possible.
5. The Plumbing Contractor shall familiarize himself with the existing conditions and notify the General Contractor of any anticipated conflicts.
6. New Sink shall be "Corbin" integral bowl with 1/2" thick top on 3/4" exterior plywood. Faucet shall be "Delta" #252911P, polished chrome and 4" wide handles.
7. New Toilet shall be "Parron" Model #091-1-175, as manufactured by Tiger.

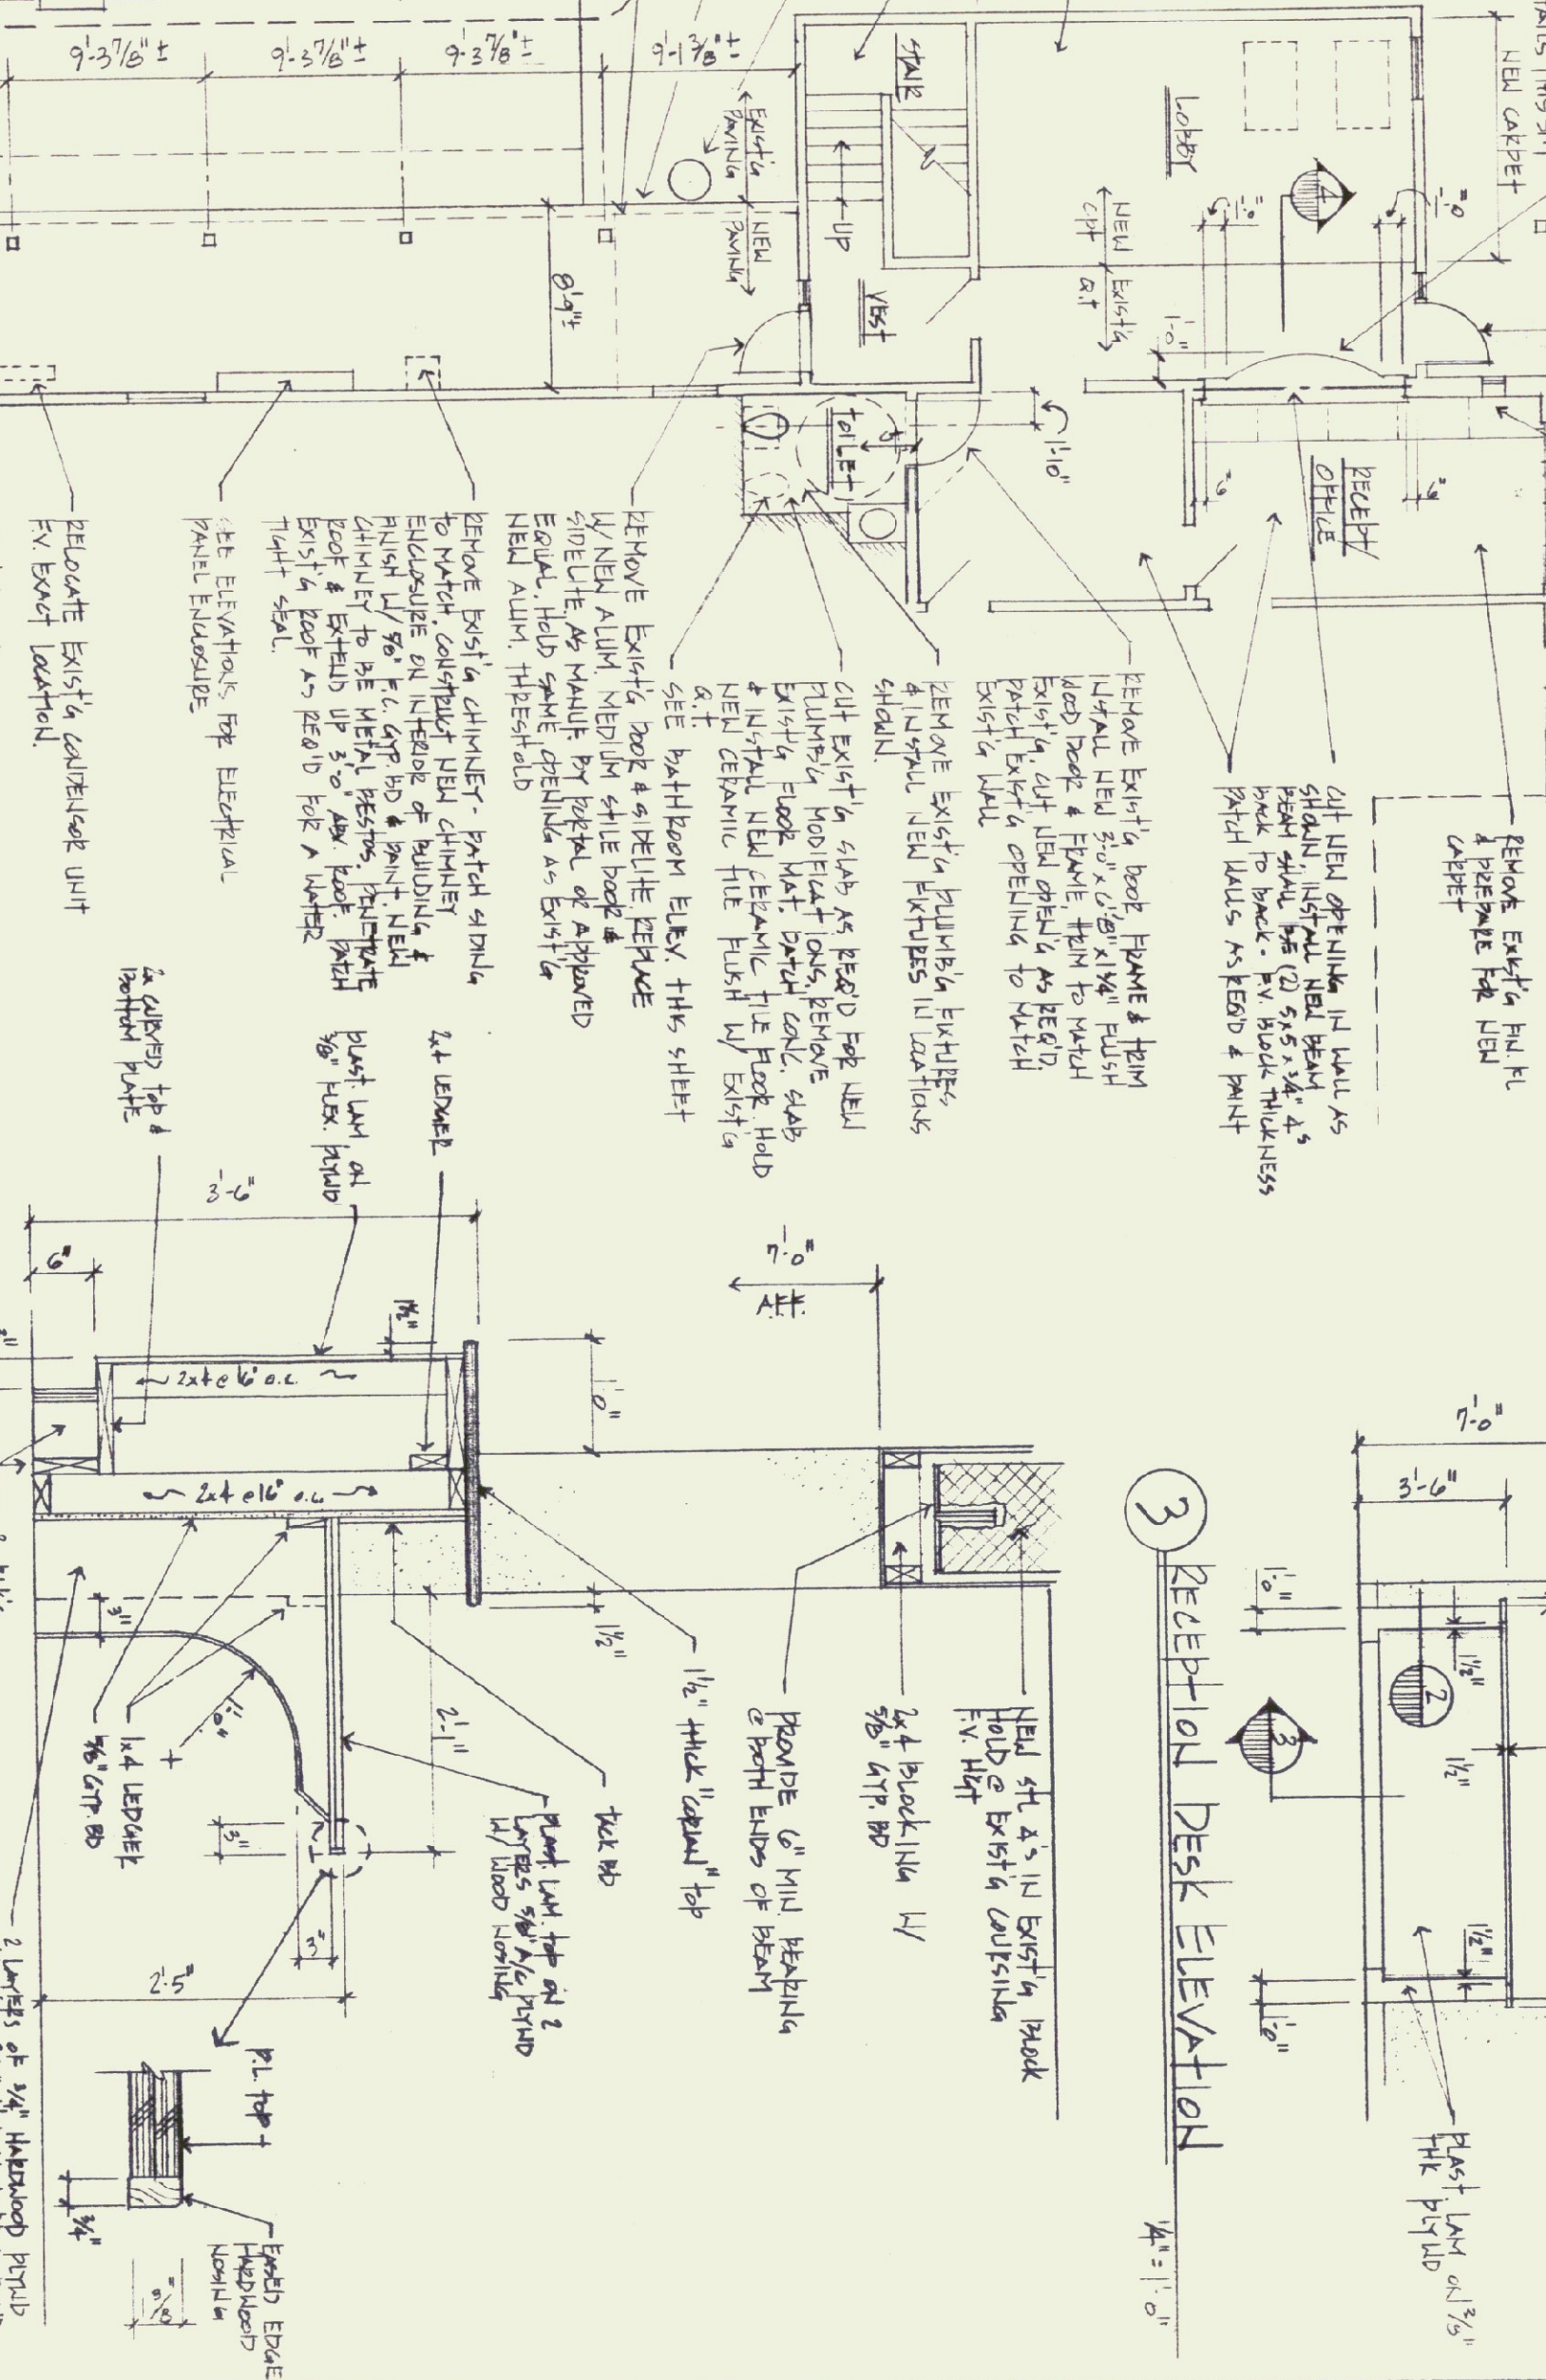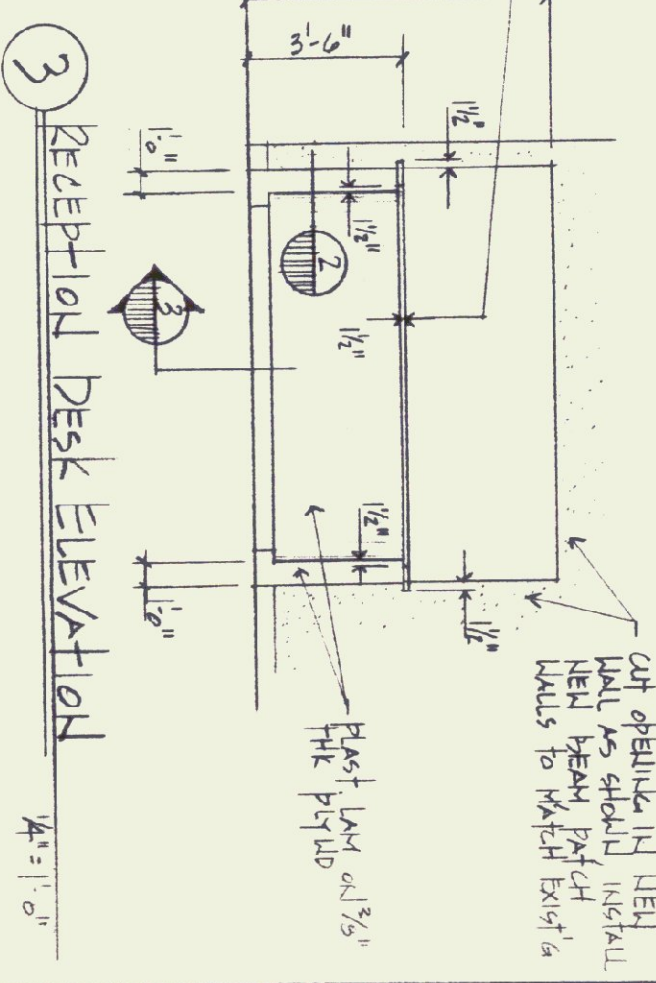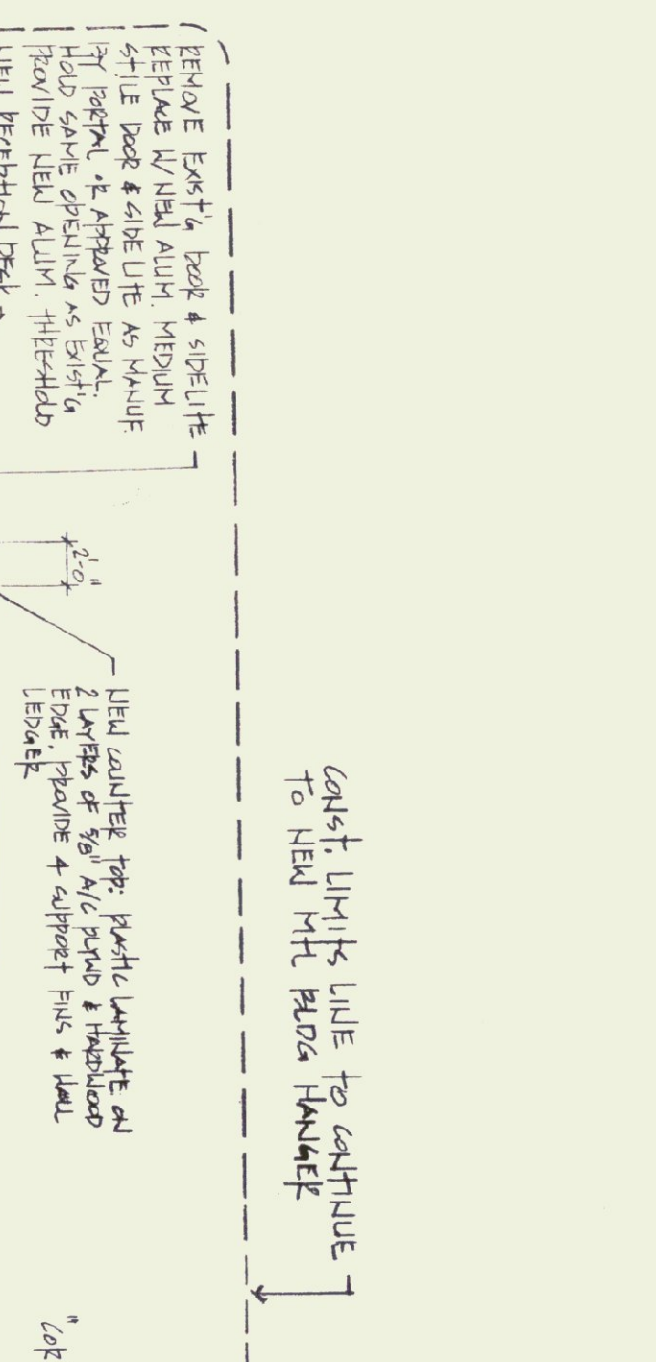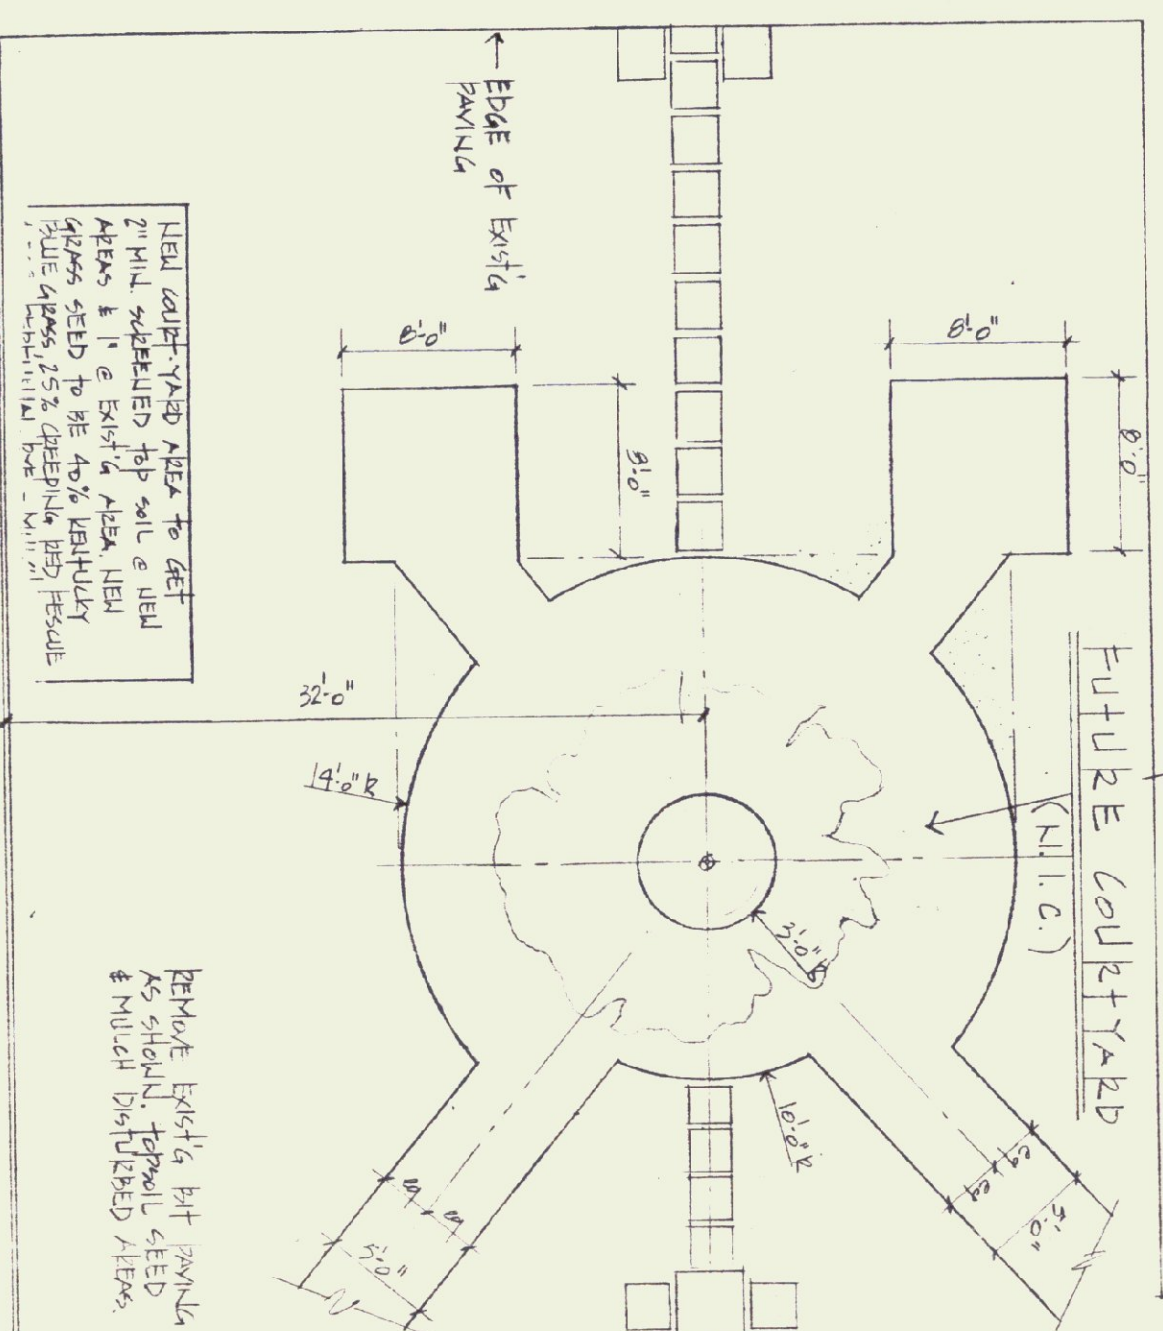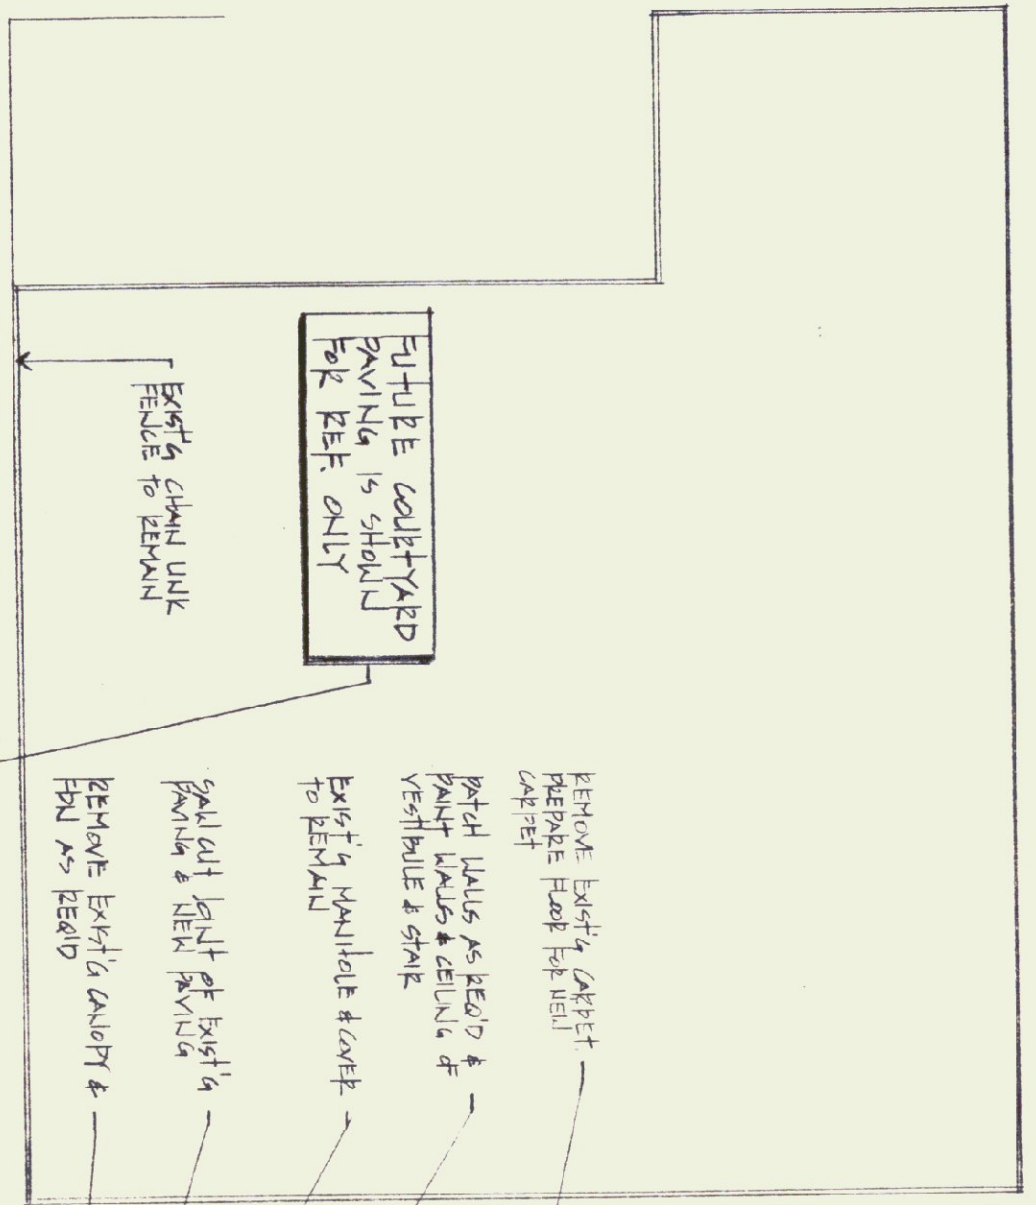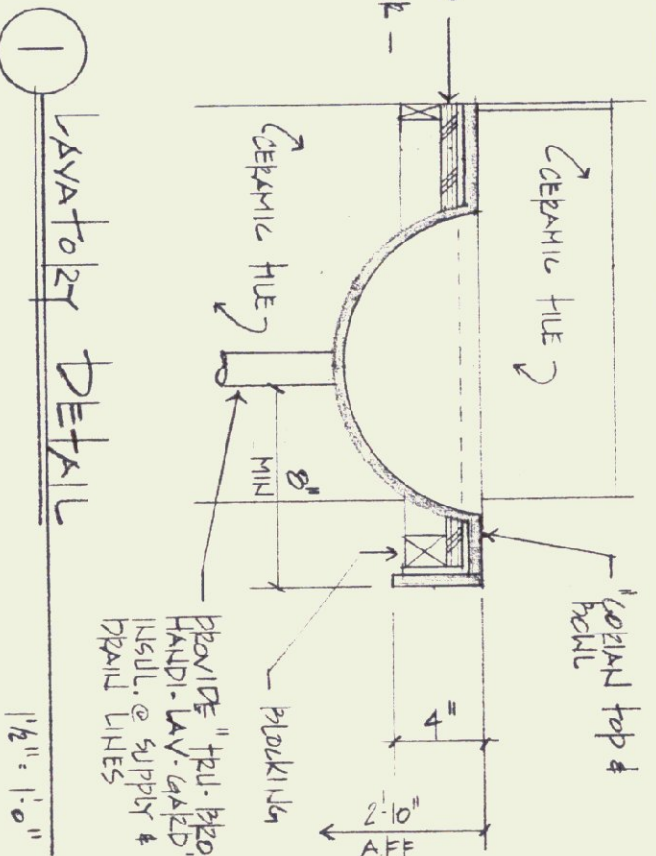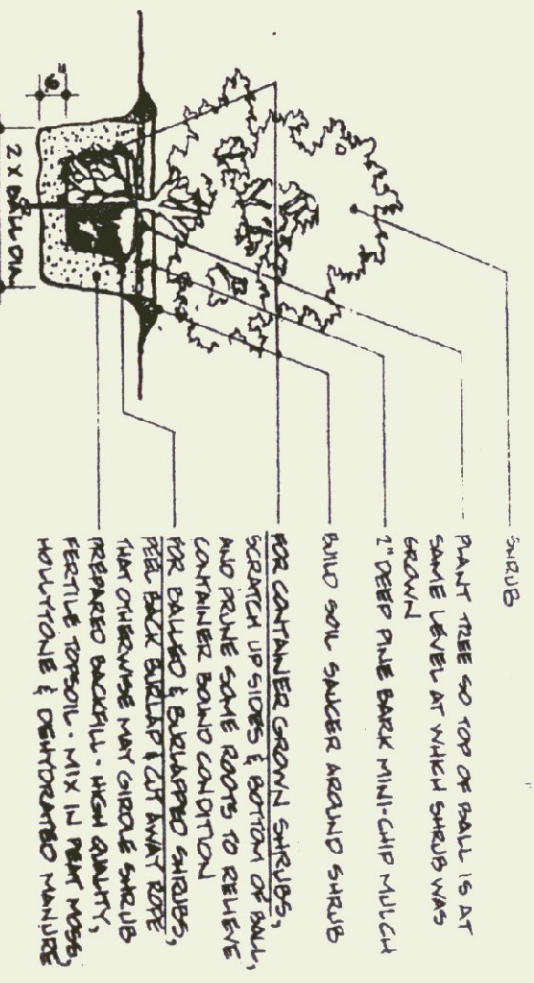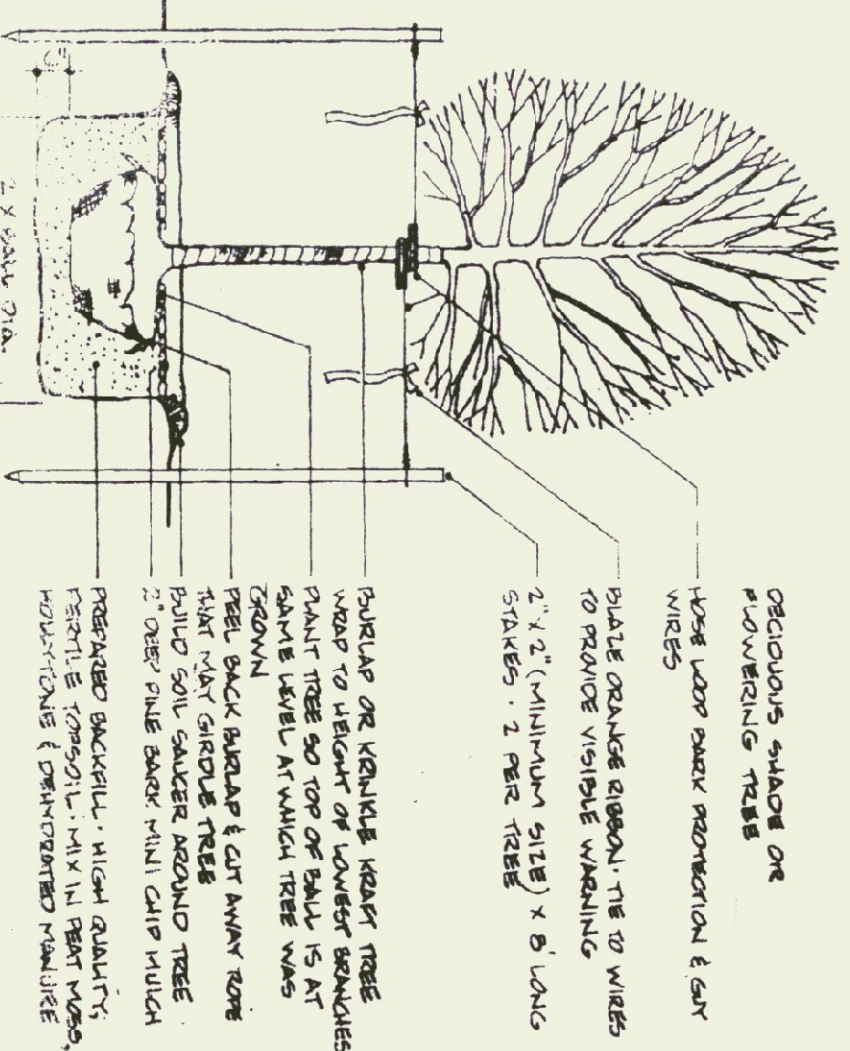

RECEPTION DESK - SECTION

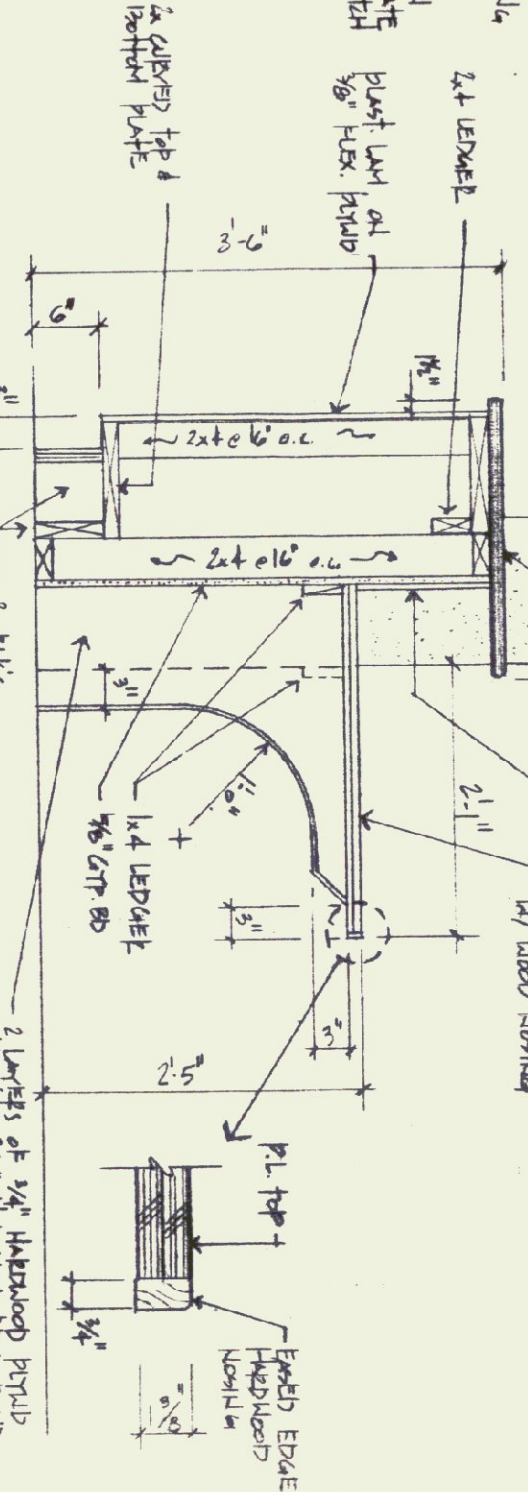

Wm. H. Morse State Airport
New Entry Canopy and Renovations

Airport Rd. Bennington, Vermont

DRAWING: PLANS & DETAILS



Jon A. Traver Associates, Architect
P.O. Box 488
North Bennington,
(802) 447-1174

13 Bank Street
Vermont 05257
Fax (802) 442-4817

JOB NO.: DWN BY: DATE: 14 MAR, 2000

ELECTRICAL NOTES:


1. All work shall be completed in accordance with the National Electric Code, State Building Code and all other applicable state and local codes.
2. All work shall be approved by state and local inspectors having jurisdiction.
3. All wiring shown is diagrammatic only. The exact method and support shall be coordinated in the field with the other trades.
4. The Contractor is responsible for verification of existing fixtures, switches, circuits, measurements and coordination with all other trades.
5. All wiring shall be concealed where possible. If exposed, provide "wire mold" one piece surface mounted steel raceway as approved by the Architect. Provide all necessary "wire mold" accessories.
6. The Contractor shall apply and be responsible for obtaining a State of Vermont Electrical Permit.

Lighting Schedule

- TYPE "B" - LIGHTCONTROL P-1-2900 "CIRC" W/ ACCE SUSPENSION & 4-CP84 LAMP
- TYPE "X" - PRESOLITE 8' SQ W/ 2-18W QUAD #CF1018585-1-HF-TK9-TL4
- TYPE "U" - PRESOLITE 16'X16'-TO-8 OPEN RECURSOR TOWNLIGHT -15W 8-50
- TYPE "V" - NATION # 871AOL FAN-LIGHT

NEW LIGHTING LAYOUT

1/8" = 1'-0"

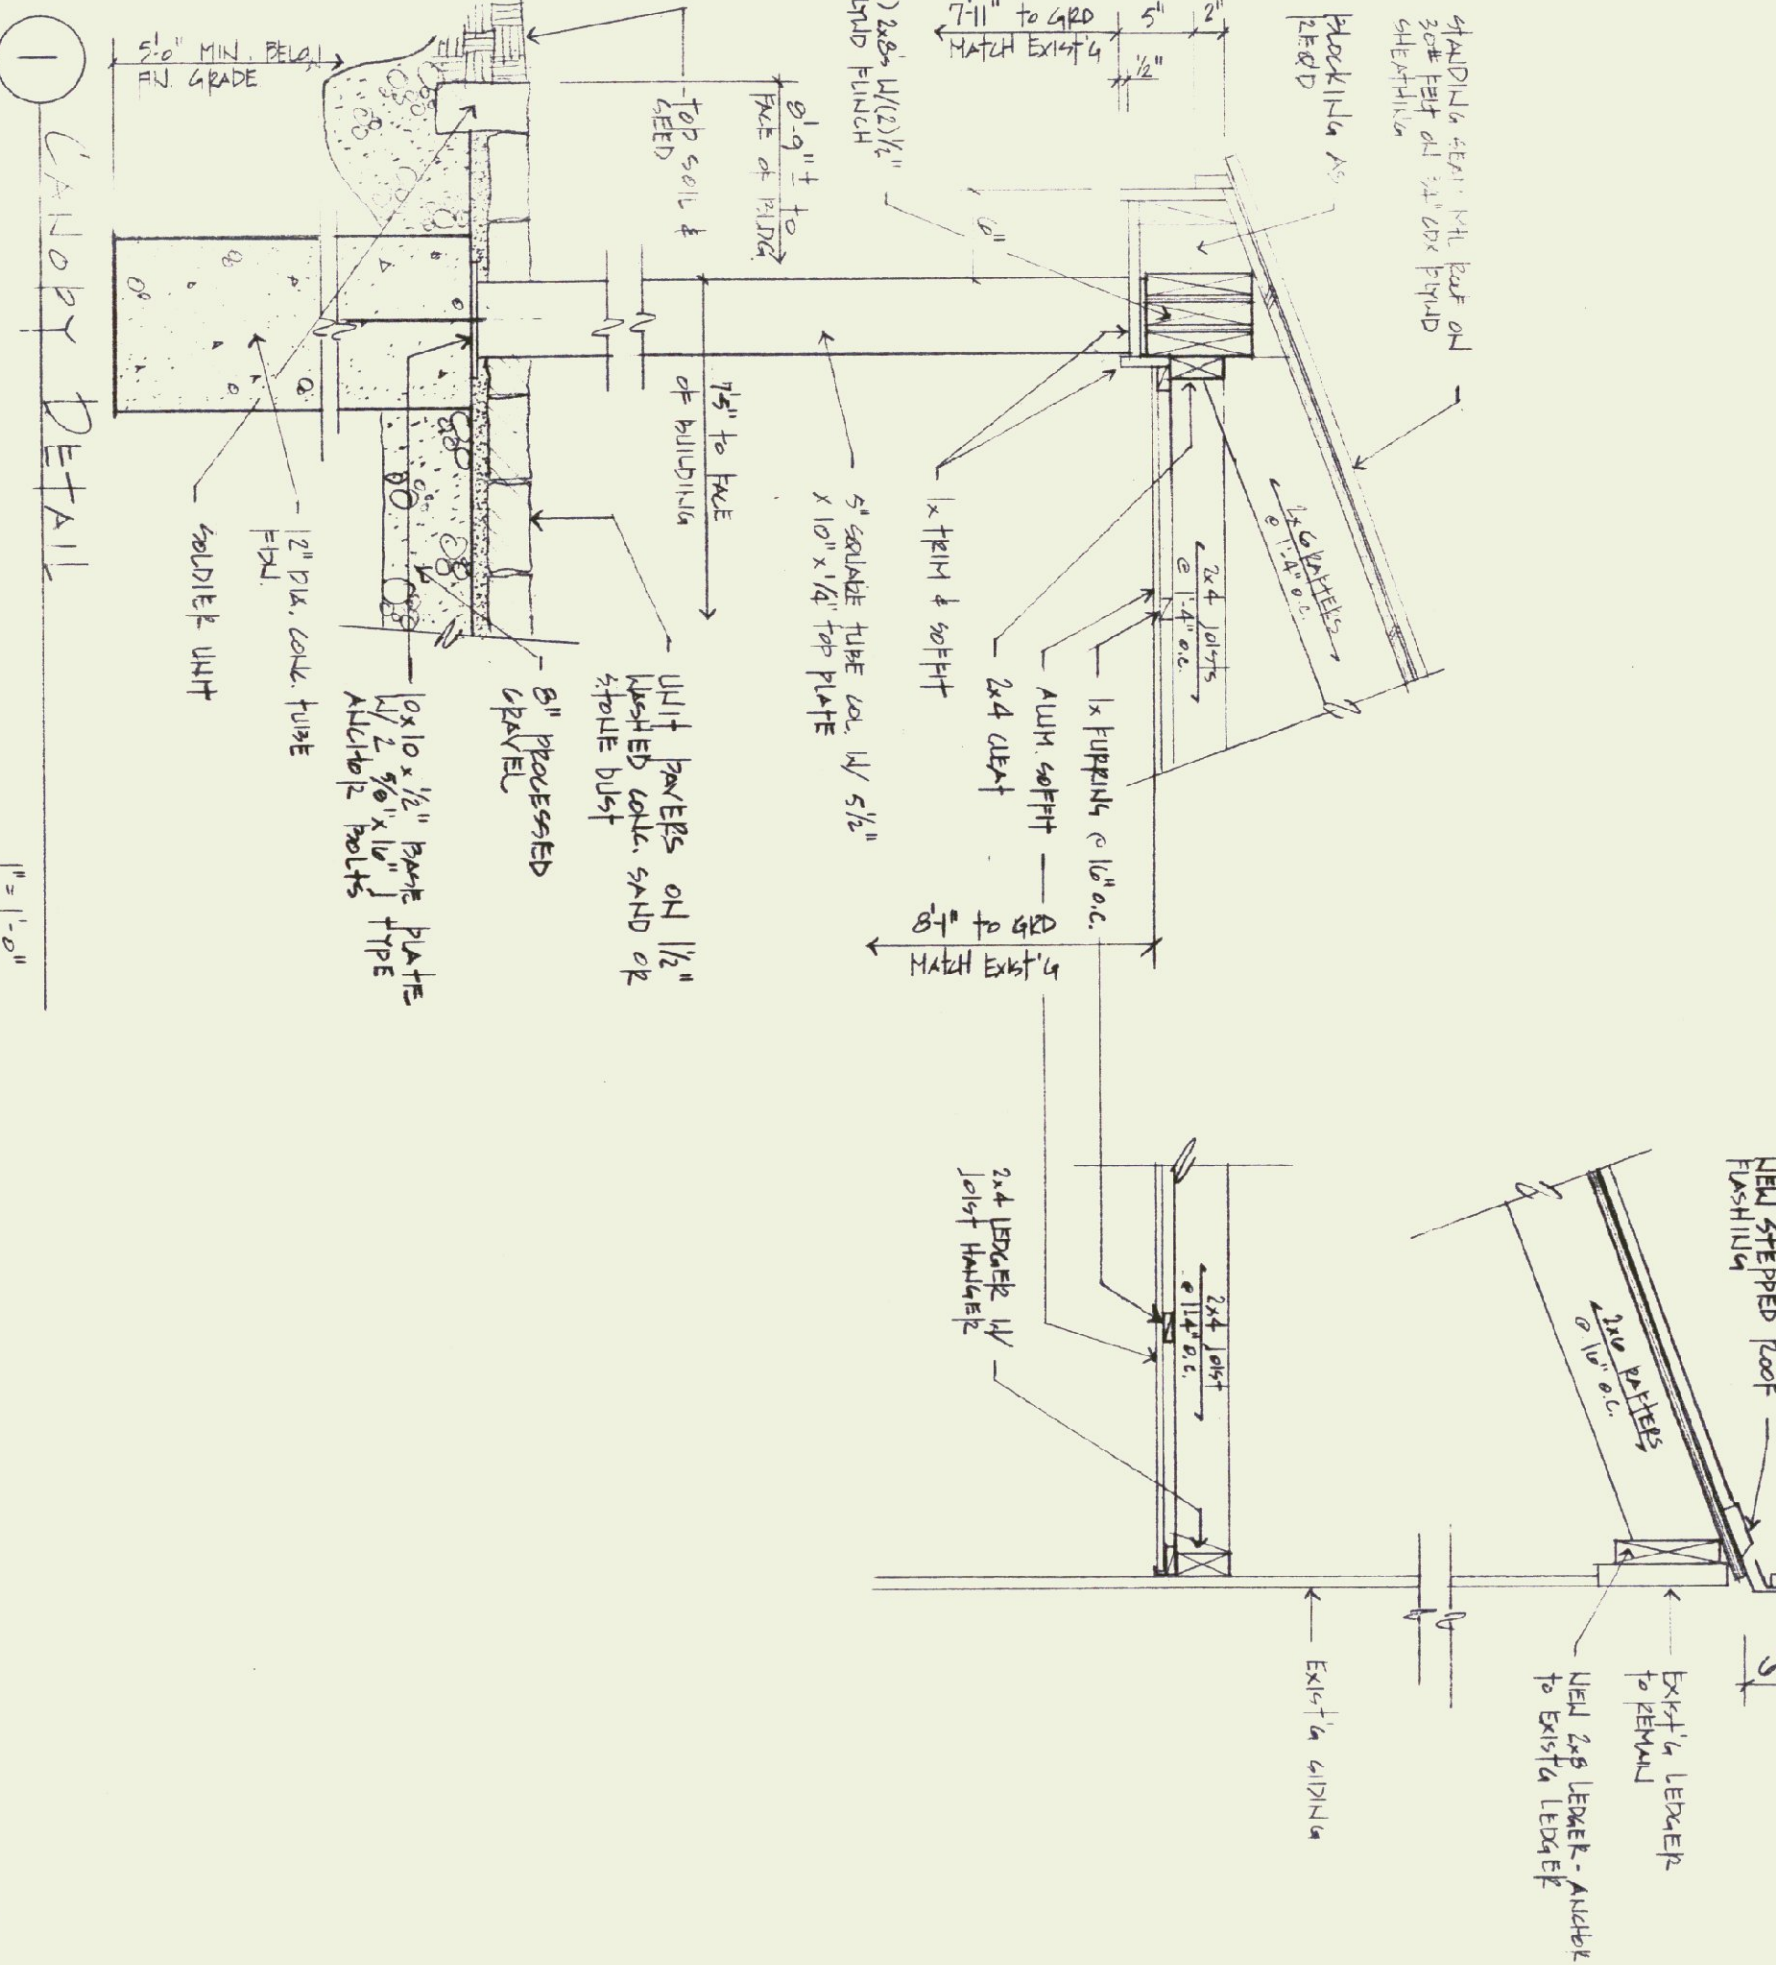


1 CANOPY DETAIL

1/8" = 1'-0"


2 NEW DOOR JAMB DETAIL

1/8" = 1'-0"

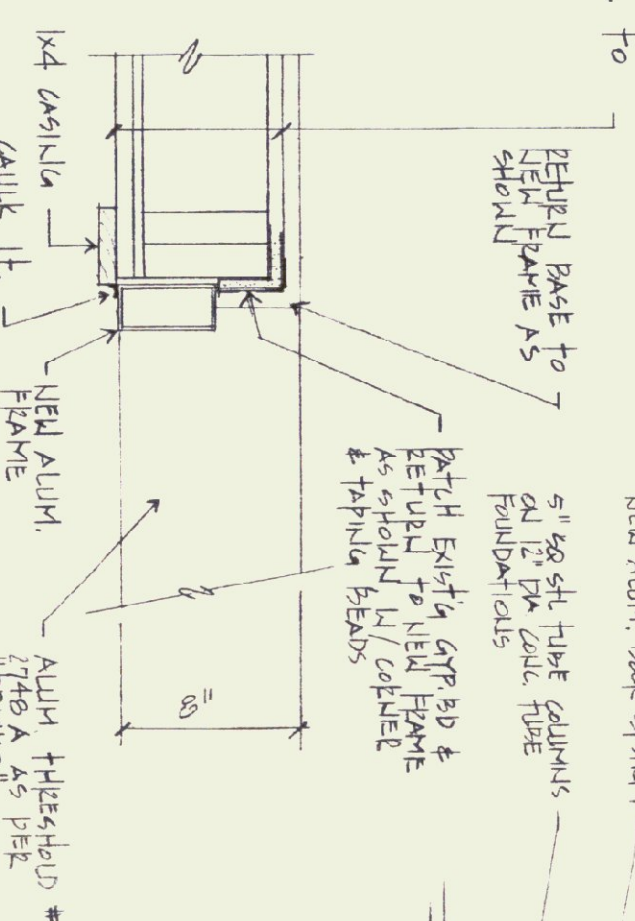


SOUTH ELEVATION

1/8" = 1'-0"

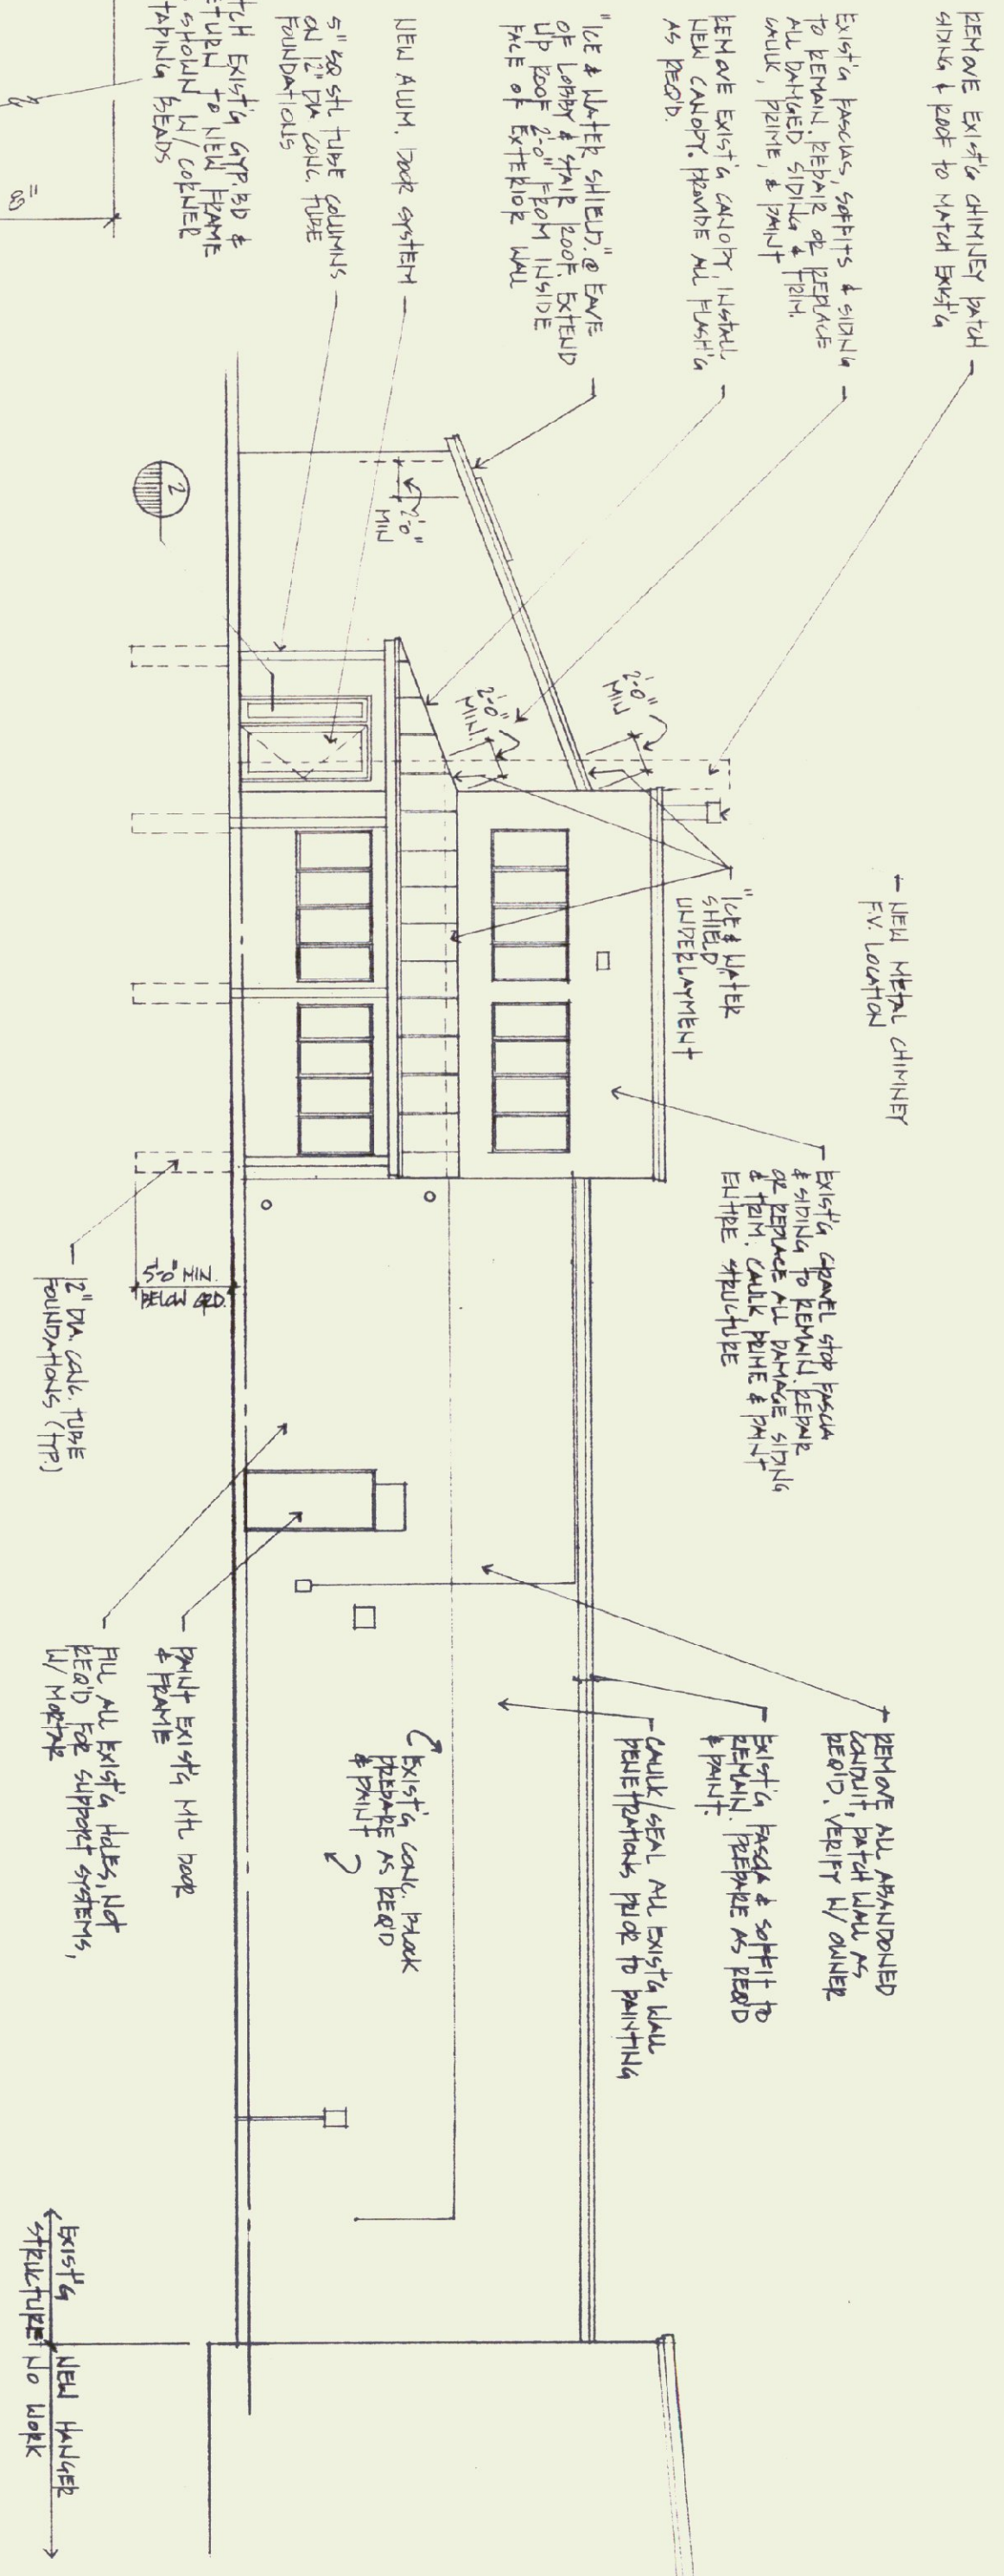

WEST ELEVATION


1/8" = 1'-0"

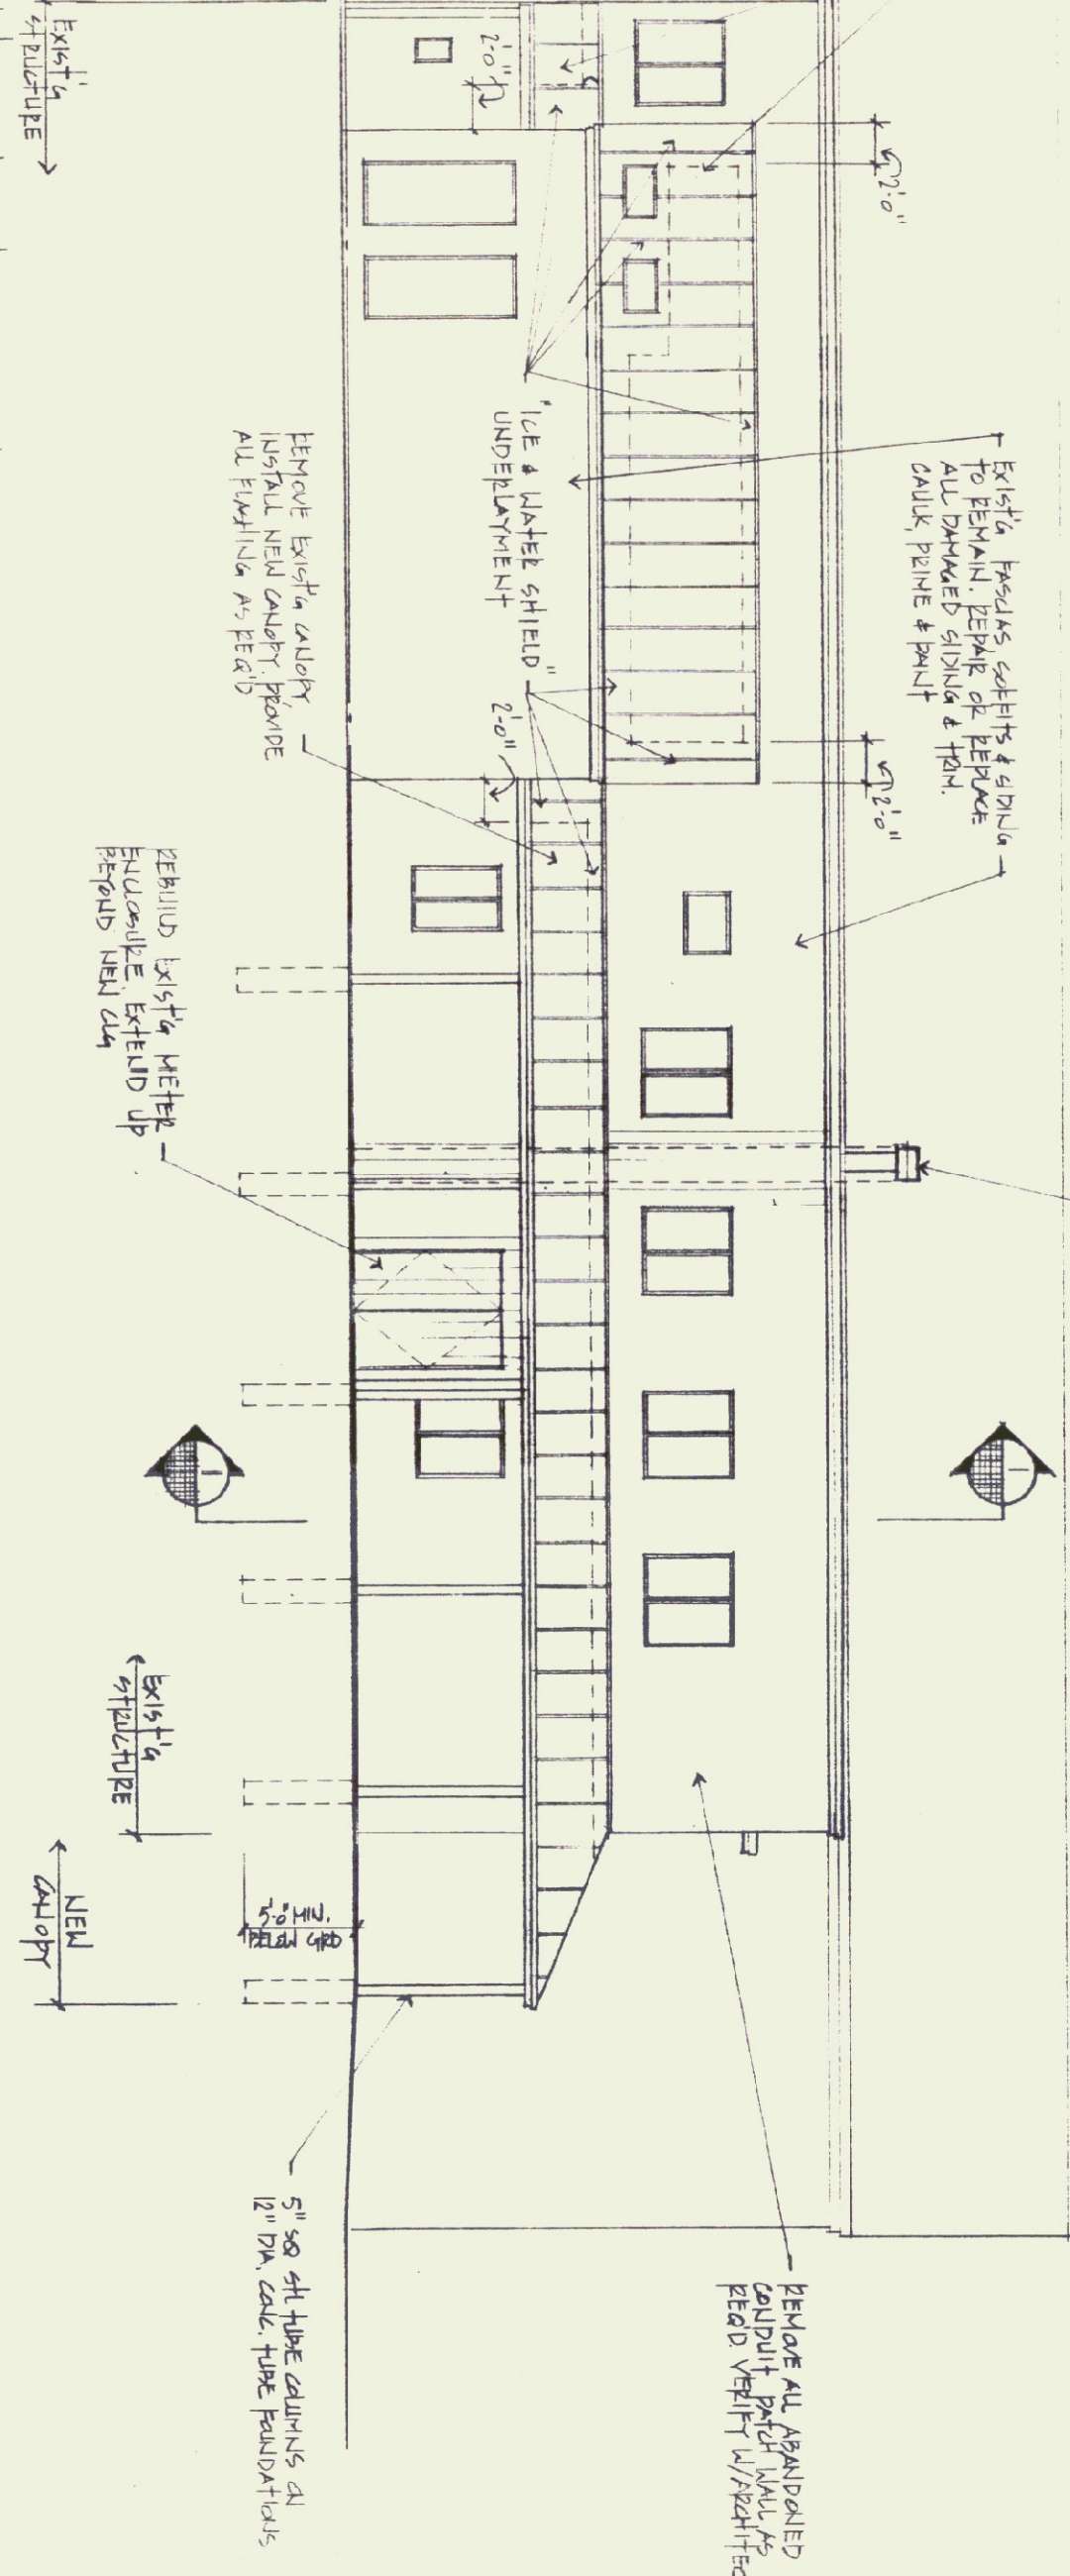

NOTE:
"ICE & LAMBER SHIELD UNDERLAMENT"
SHALL BE AS MANUFACTURED BY GORHAM
CONSTRUCTION PRODUCTS, CAPTIONED VIA
OF APPROVED COLOR BY ARCHITECT.

NORTH ELEVATION

1/8" = 1'-0"

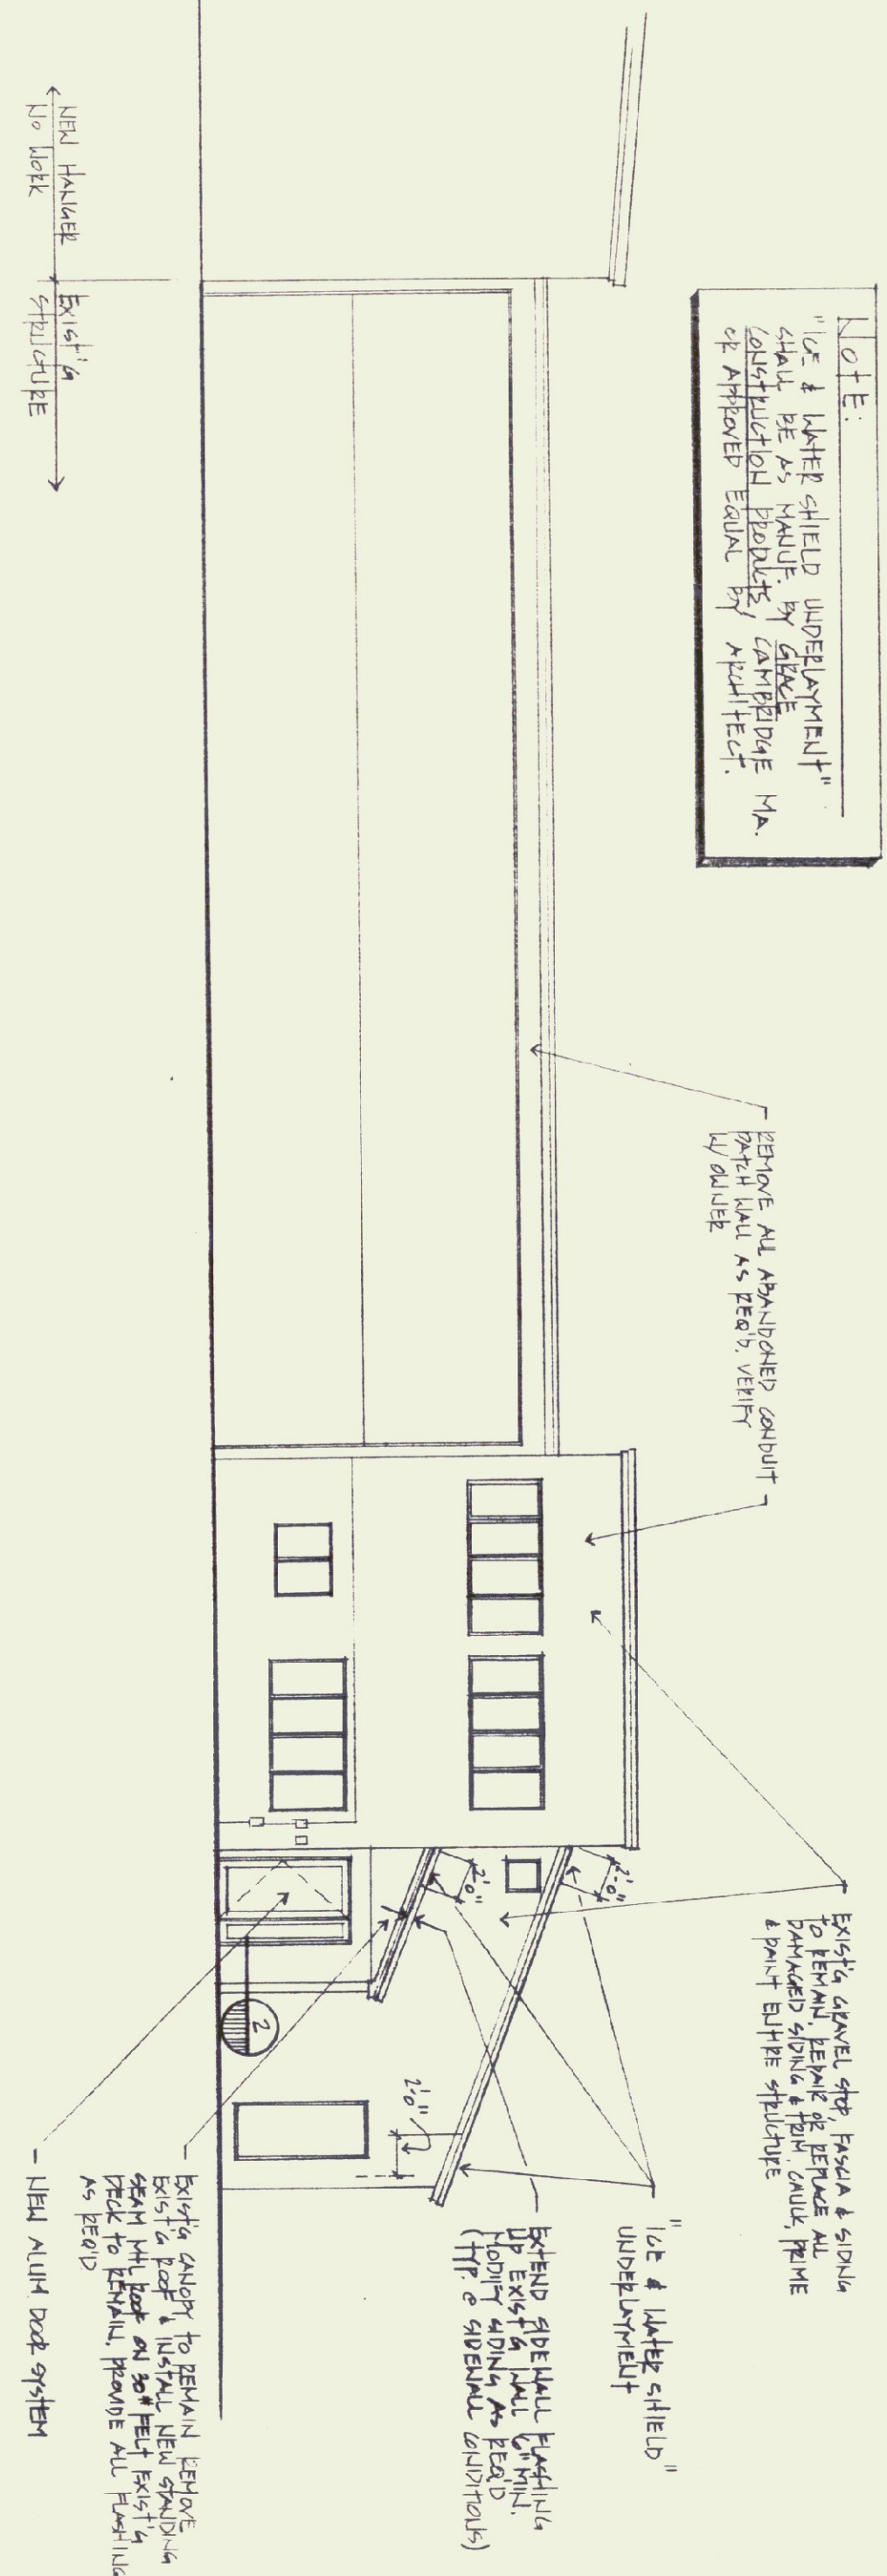

Wm. H. Morse State Airport
New Entry Canopy and Renovations

Airport Rd. Bennington, Vermont

DRAWING: ELEVATIONS, DETAILS, ELECTRICAL



Jon A. Traver Associates, Architect
P.O. Box 488
North Bennington,
(802) 447-1174

13 Bank Street
Vermont 05257
Fax (802) 442-4817

JOB NO.: DWN BY: H/3/H DATE: 14 MAR 2000