

SUMMARY OF QUANTITIES			
BASE BID			
ITEM NO.	DESCRIPTION	UNITS	QUANTITY
203.17	UNCLASSIFIED EXCAVATION	CY	2000.00
203.26	EXCAVATION OF SURFACES & PAVEMENTS	CY	1.50
203.30	EARTH BORROW	CY	1400.00
203.32	GRANULAR BORROW	CY	2060.00
203.40	FINE GRADING SUBGRADE	SY	3160.00
204.20	TRENCH EXCAVATION	CY	31.00
301.26	SUBBASE OF CRUSHED STONE	CY	805.00
404.65	EMULSIFIED ASPHALT PRIME COAT	CWT	62.00
406.25	BITUMINOUS CONCRETE PAVEMENT	TON	551.00
501.30	CONCRETE CLASS C	CY	30.00
507.15	REINFORCING STEEL	LB	436.00
601.0015	18" C.S.P.	LF	211.00
601.6015	18" C.S.P.E.S.	EA	5.00
604.21	PRECAST REINFORCED CONCRETE MH	EA	1.00
604.51	CAST IRON GRATE - TYPE D	EA	1.00
613.10	STONE FILL - TYPE 1	CY	2.00
635.10	MOBILIZATION	LS	1.00
649.20	GEOTEXTILE FABRIC FOR SILT FENCE	SY	230.00
651.15	SEED	LB	40.00
651.18	FERTILIZER	LB	330.00
651.20	AGRICULTURAL LIMESTONE	TON	1.32
651.25	HAY MULCH	TON	1.32
651.35	TOPSOIL	CY	180.00
875.00	JOINT SEALANT - FUEL RESISTANT	GAL	5.00
1000.00	EXISTING TANK REMOVAL AND BACKFILL	LS	1.00
1001.00	PROPOSED TANK INSTALLATION	LS	1.00
1002.00	AVIATION FUELING CABINET	LS	1.00
1003.00	PIPING & VALVE SUPPORTS	LS	1.00
1004.00	BALLAST & SURFACE PADS	LF	700.00
1005.00	LEAK DETECTION SYSTEM	LS	1.00
1006.00	TANK TESTING & START UP	EA	1.00
1007.00	TRENCHING AND ELECTRICAL CONDUITS	LS	1.00
1008.00	EXPLOSION PROOF PANEL BOARD	LS	1.00
1009.00	ELECTRICAL EQUIPMENT	LS	1.00
ADDITIVE ALTERNATIVE 1			
203.28	EXCAVATION OF SURFACES & PAVEMENTS	CY	1.00
404.25	BITUMINOUS CONCRETE PAVEMENT	TON	114.00
404.65	EMULSIFIED ASPHALT	CWT	32.00

STATE OF VERMONT

AGENCY OF TRANSPORTATION



PROPOSED IMPROVEMENT

TOWN OF MIDDLEBURY



COUNTY OF ADDISON

MIDDLEBURY STATE AIRPORT

AVGAS FUELING SYSTEM


AIR 03-2069

JULY 1990

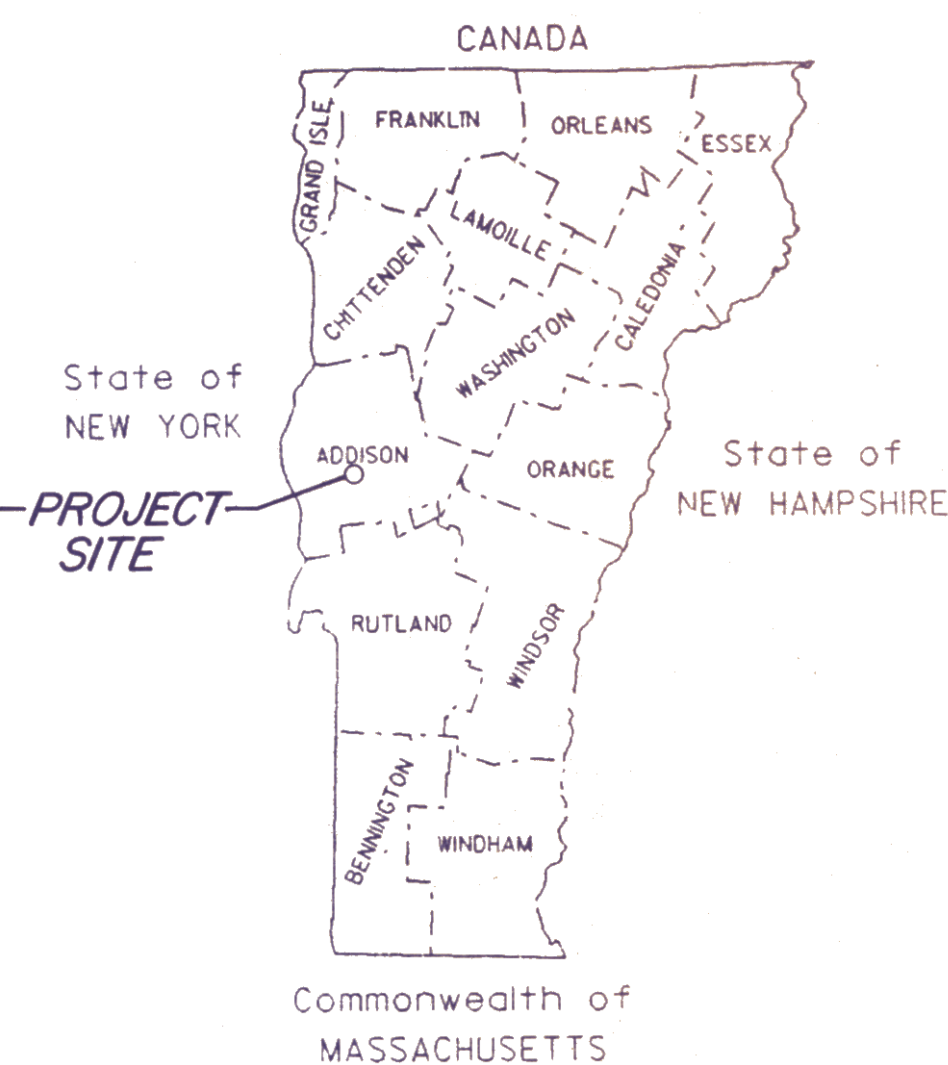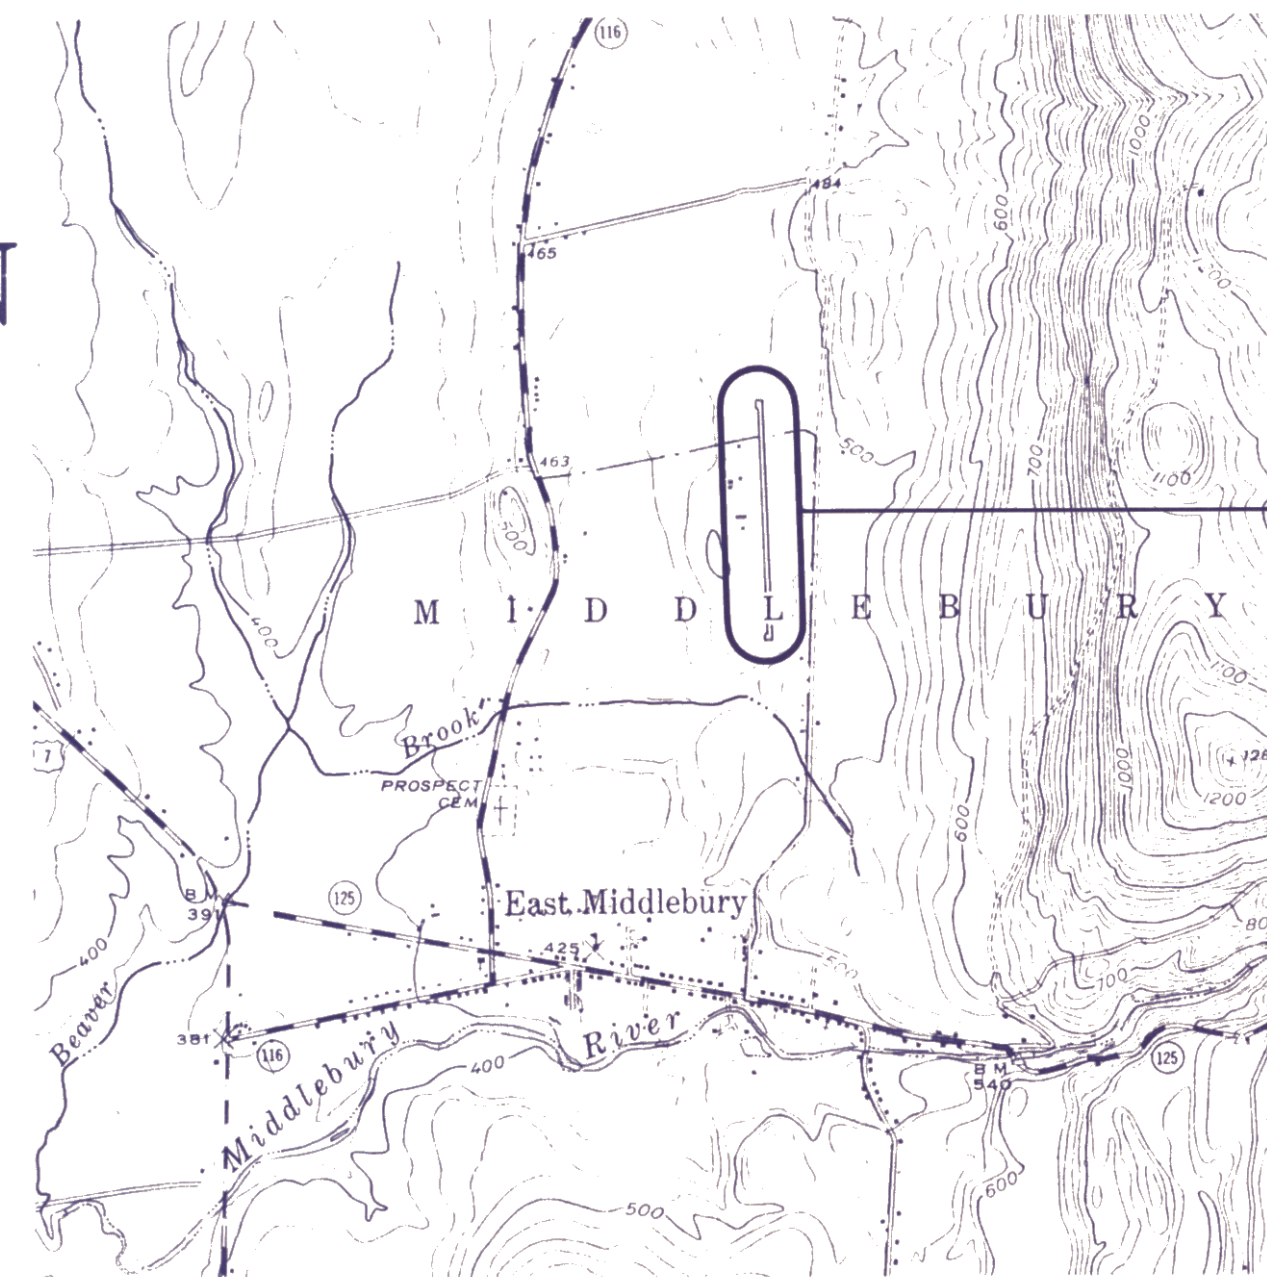

LEGEND

- BORING LOCATION
- EXISTING CONTOURS
- PROP CORRUGATED STEEL PIPE (C.S.P.)
- C.S.P. END SECTION (V.A.O.T. STANDARD D-4)
- STONE FILL OUTLET PROTECTION

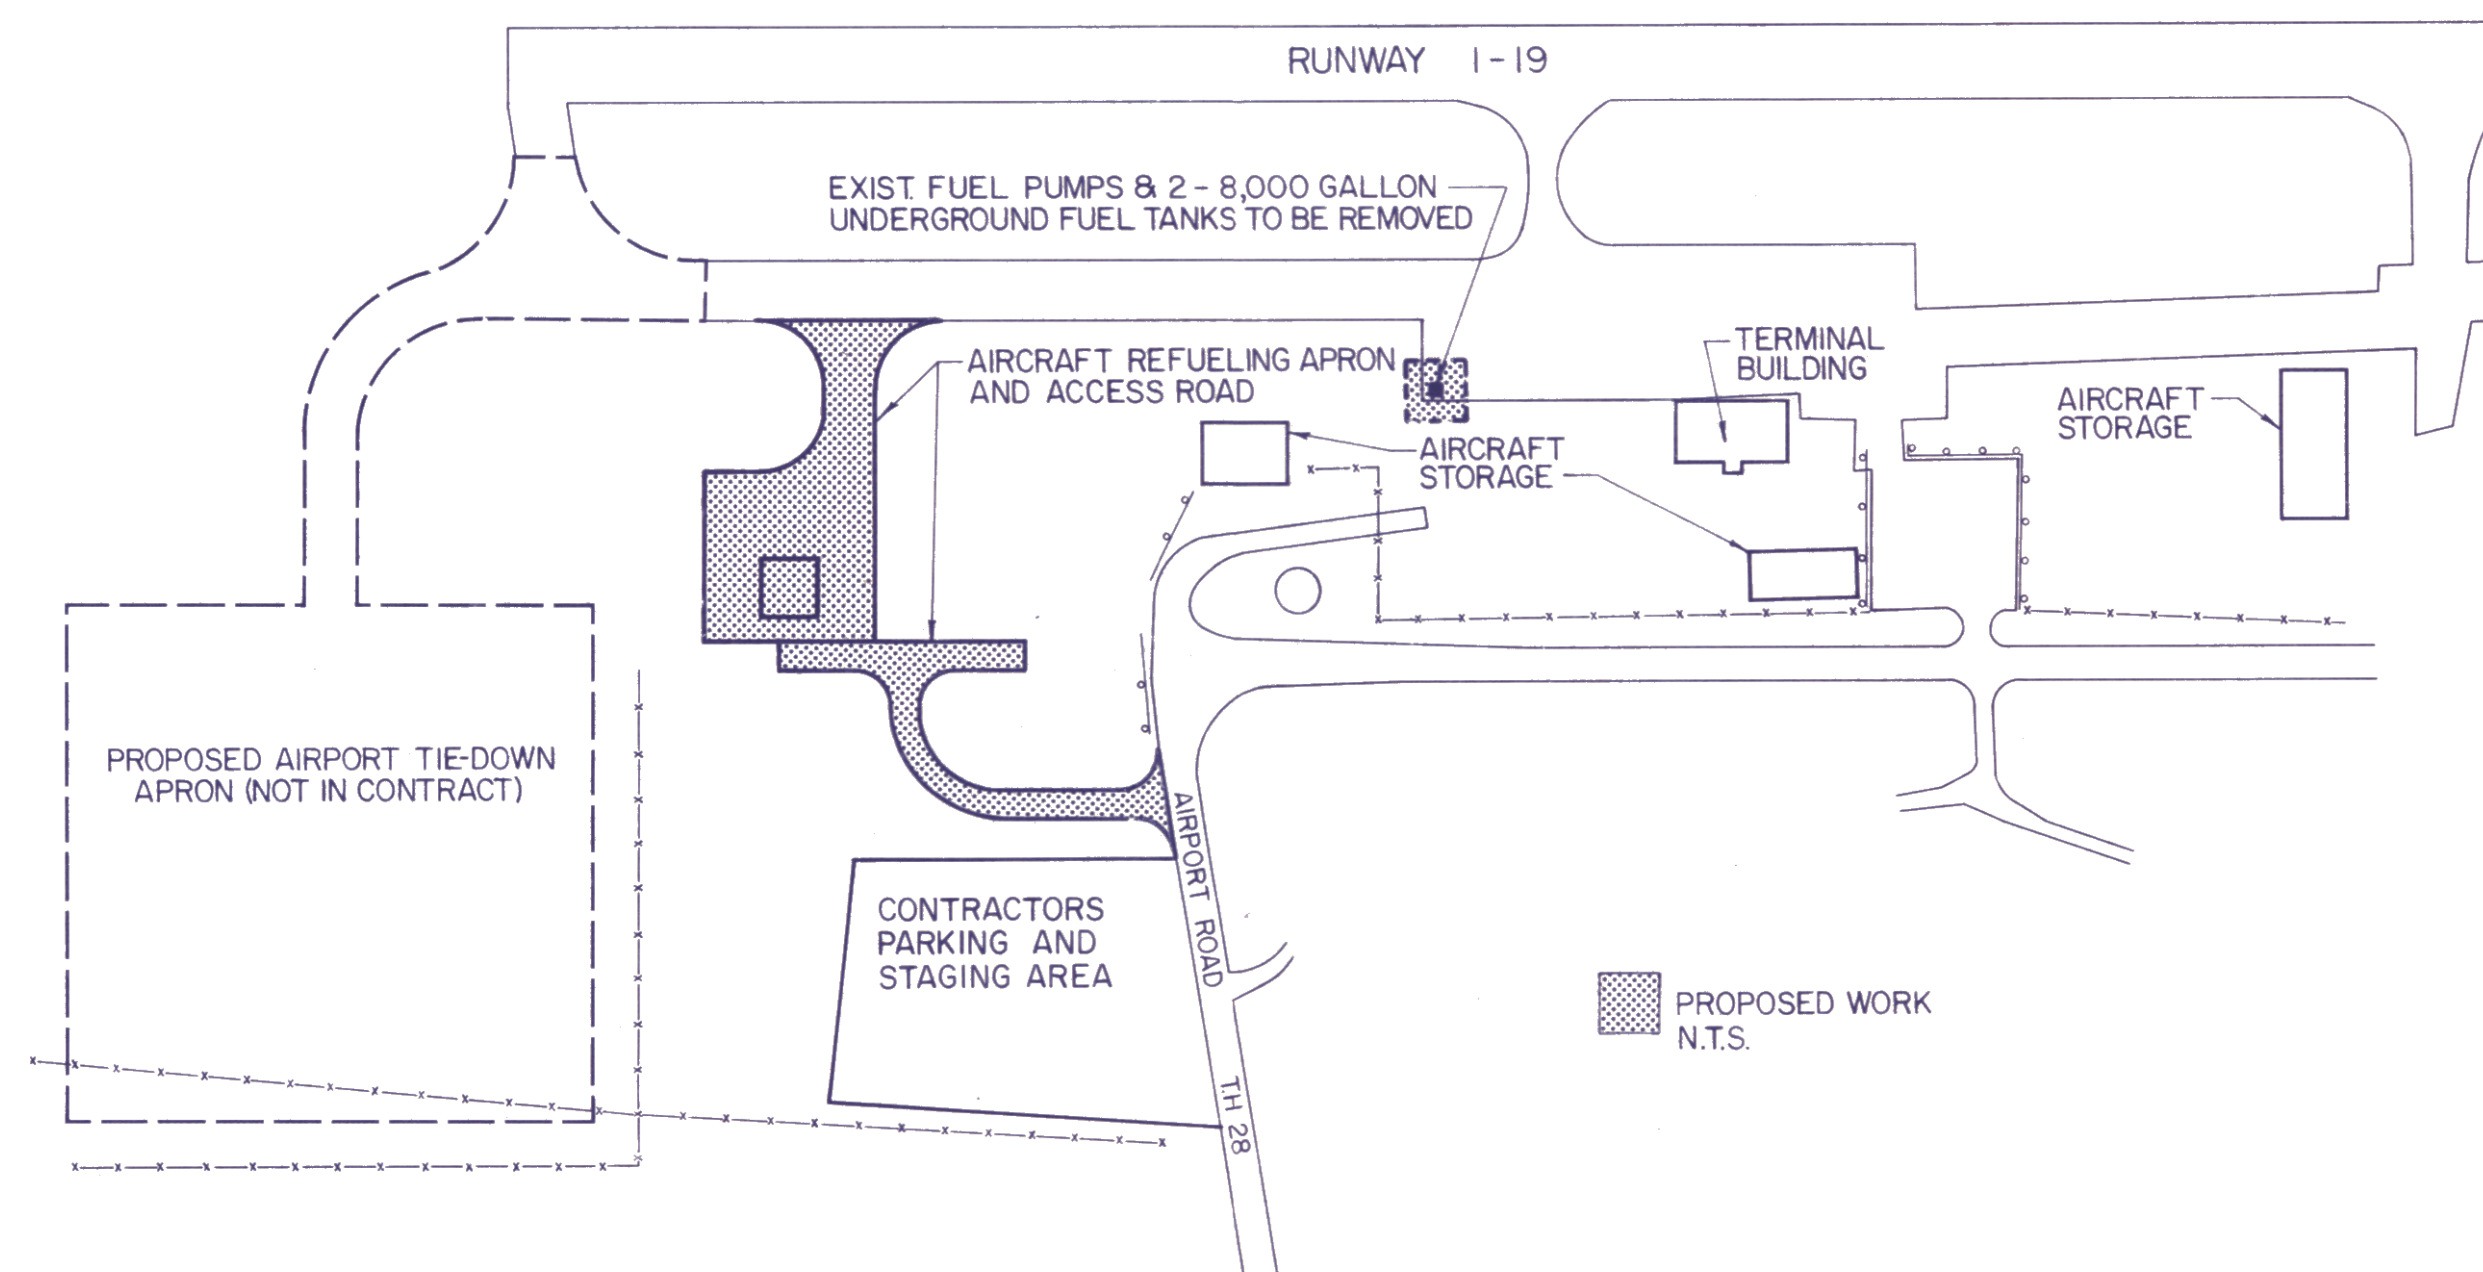

INDEX OF SHEETS

TITLE	DATE	DRAWING NO.
TITLE SHEET	JULY 1990	-
SITE PLAN	JULY 1990	SP-1
SITE PLAN	JULY 1990	SP-2
TYPICAL SECTIONS	JULY 1990	TS-1
PROFILES	JULY 1990	PF-1
DETAILS	JULY 1990	D-1
APRON CROSS SECTIONS	JULY 1990	CS-1
ACCESS ROAD CROSS SECTIONS	JULY 1990	CS-2
TANK AND REFUELING CABINET PLAN	JULY 1990	M-1
ELECTRICAL PLAN	JULY 1990	E-1



CLOUGH, HARBOUR

& ASSOCIATES

ENGINEERS & PLANNERS

REV. NO.	DATE	DESCRIPTION	REV. NO.	DATE	DESCRIPTION

C.H.A. PROJECT NO. 1981-03

