



GARAGE PRELIMINARY
DETAILS AND LOCATION
SEE SK-3

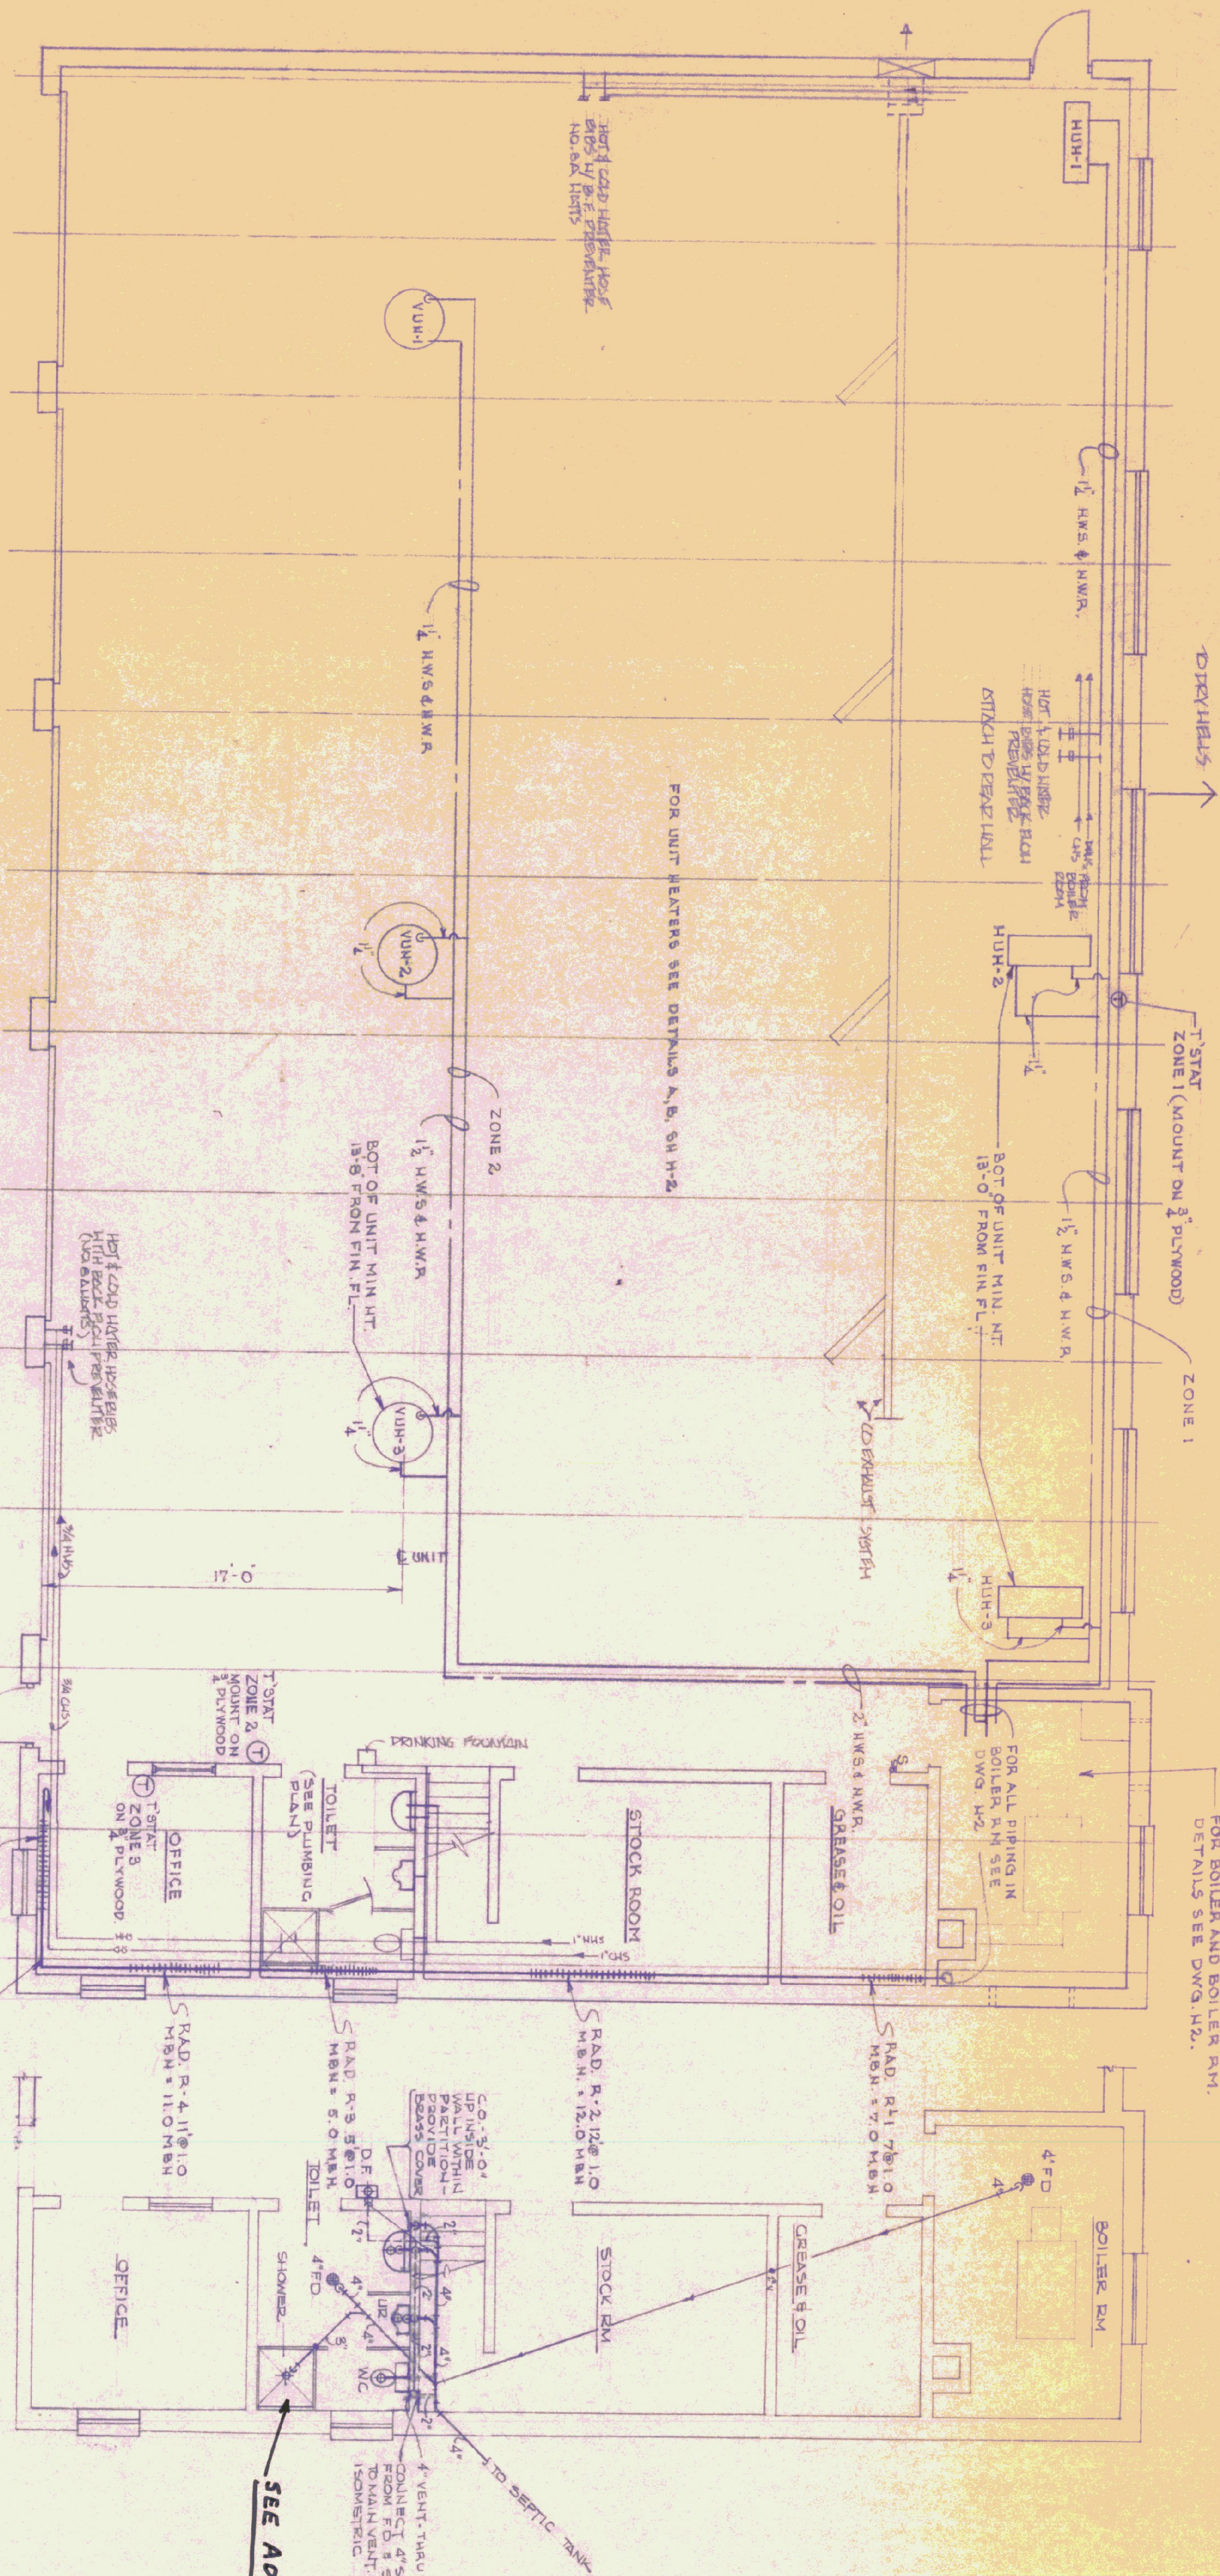


HEATING PLAN
(5 BAY)
SCALE: 3/8" = 1'-0"

DETAIL OF END OF MAIN (GARAGE OFFICE)
SCALE: 1/2" = 1'-0"

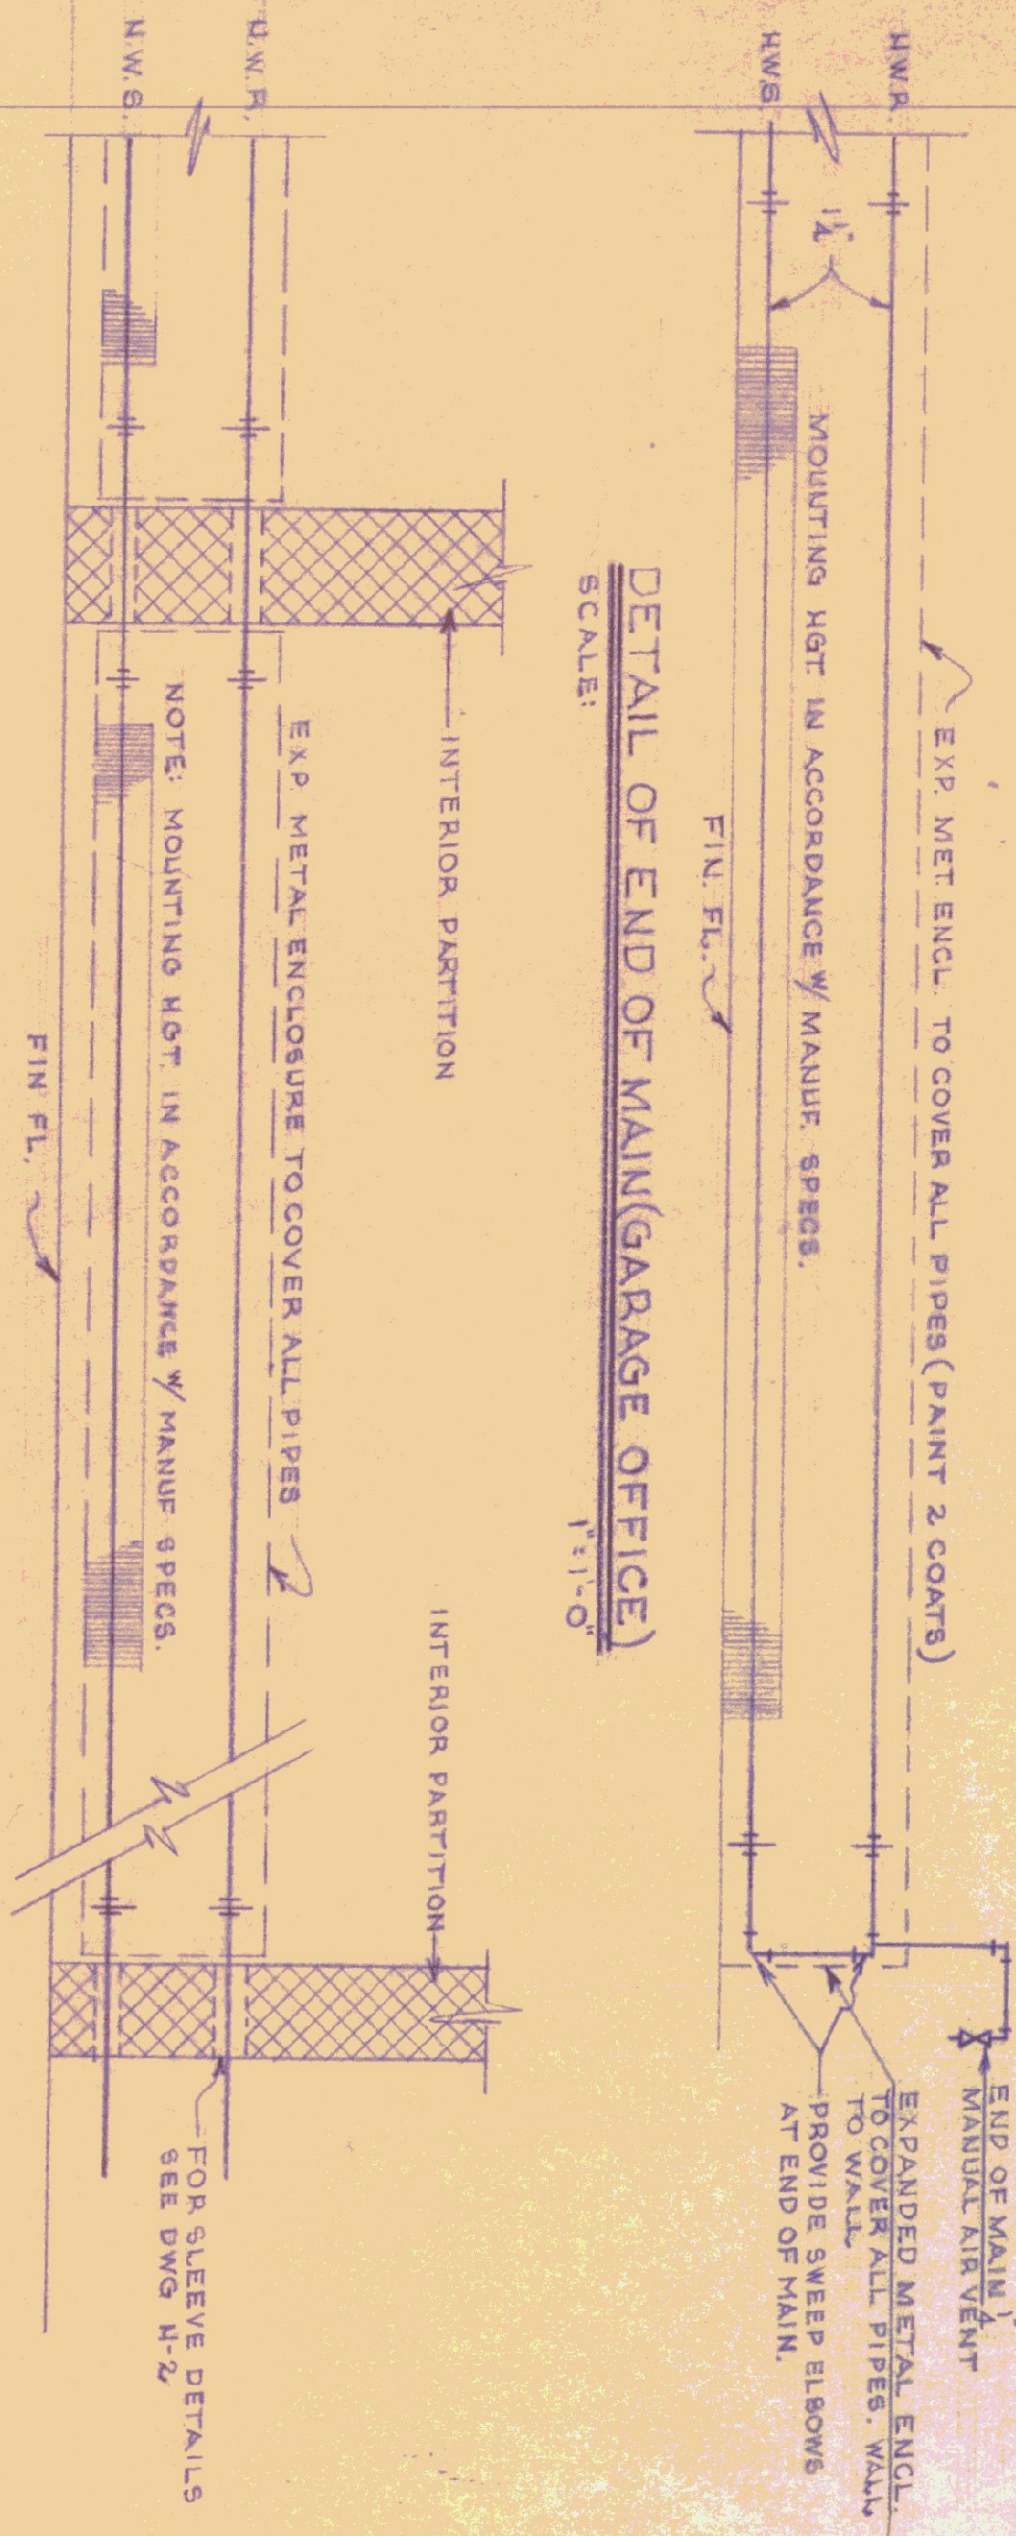


TYPICAL BASEBOARD RADIATION PIPING
SCALE: 1/2" = 1'-0"


TYPICAL SECTION
SCALE: 1/2" = 1'-0"

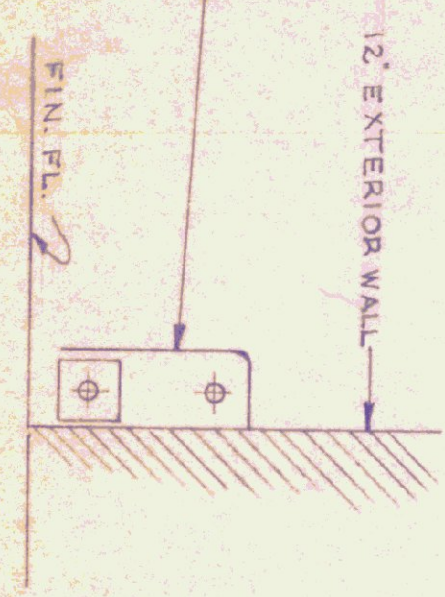

PLUMBING PLAN
SCALE: 3/8" = 1'-0"

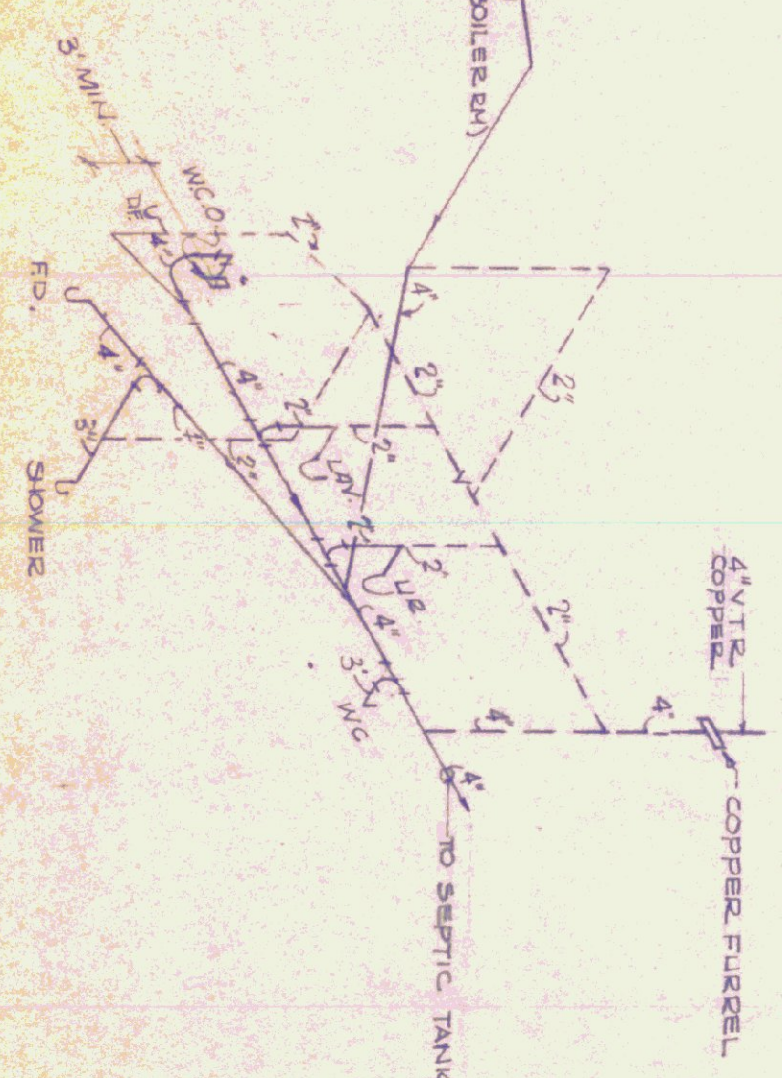

PLUMBING ISOMETRIC DIAGRAM
SCALE: 3/8" = 1'-0"

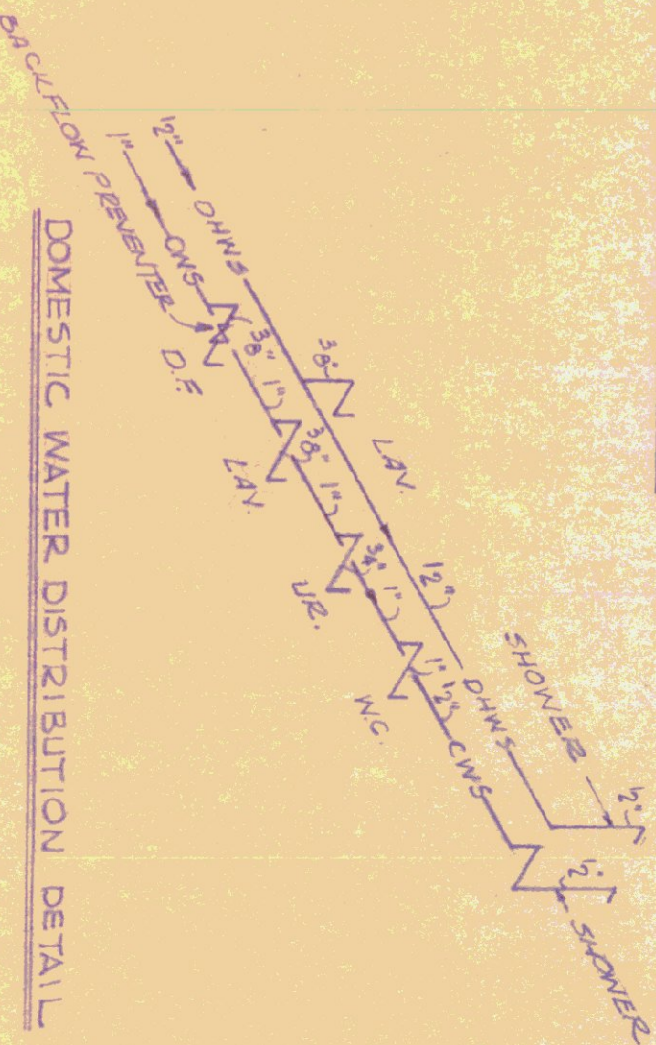

DOMESTIC WATER DISTRIBUTION DETAIL
SCALE: 3/8" = 1'-0"

SEE DRAWING H-2 FOR SCHEDULE 40 GENERAL NOTES

- LEGEND
- H.W.S. - HOT WATER SUPPLY
 - H.W.R. - HOT WATER RETURN
 - 5/8" - BURNER SAFETY SWITCH (GAS) @ GAS VALVE
 - UH - T STAYS
 - UH - PIPE SUPPLY TO BOTTOM & RETURN TO TOP
 - 4" - GATE VALVE
 - 2" - CHECK VALVE
 - 2" - BALANCING COCK
 - 2" - FLOW CONTROL VALVE
 - 2" - UNION
 - 2" - FUSIBLE LEVER-MATIC VALVE
 - 2" - STEAMER
 - 2" - PRV - ALL BRONZE
 - 2" - R/C FROM REPAIRS

REVISIONS	DATE	REVISION
1	10-18-74	AS NOTED

STATE OF VERMONT
DIVISION OF STATE BUILDINGS
AGENCY OF ADMINISTRATION

MONTPELIER, VERMONT

Standard Five Bay Highway Garage Bldg.

HEATING PLAN

SCALE: AS NOTED

DATE: 10-18-74	DESIGNED BY: CUS. MASTRO	DWG. NO. H1
DRAWN BY: J. B. B.	APPROVED BY: J. B. B.	1 OF 1
STUDIO SETTING		