
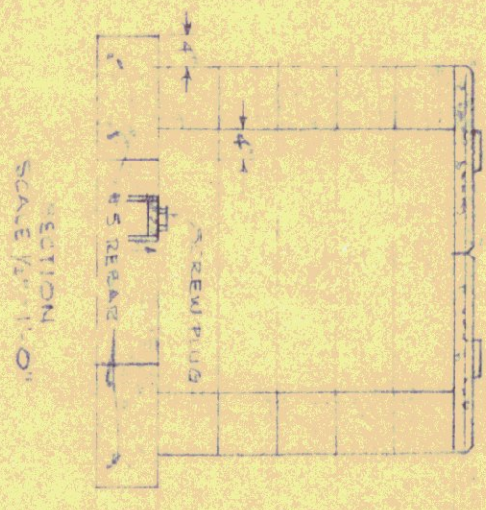
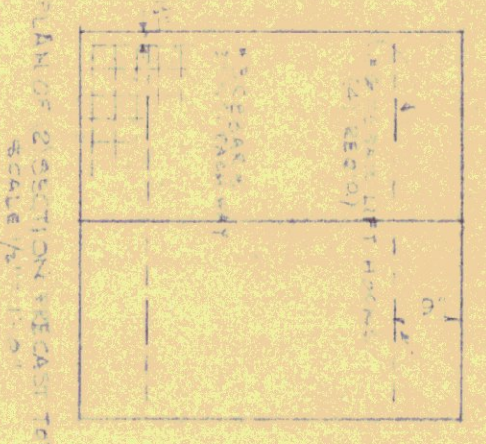
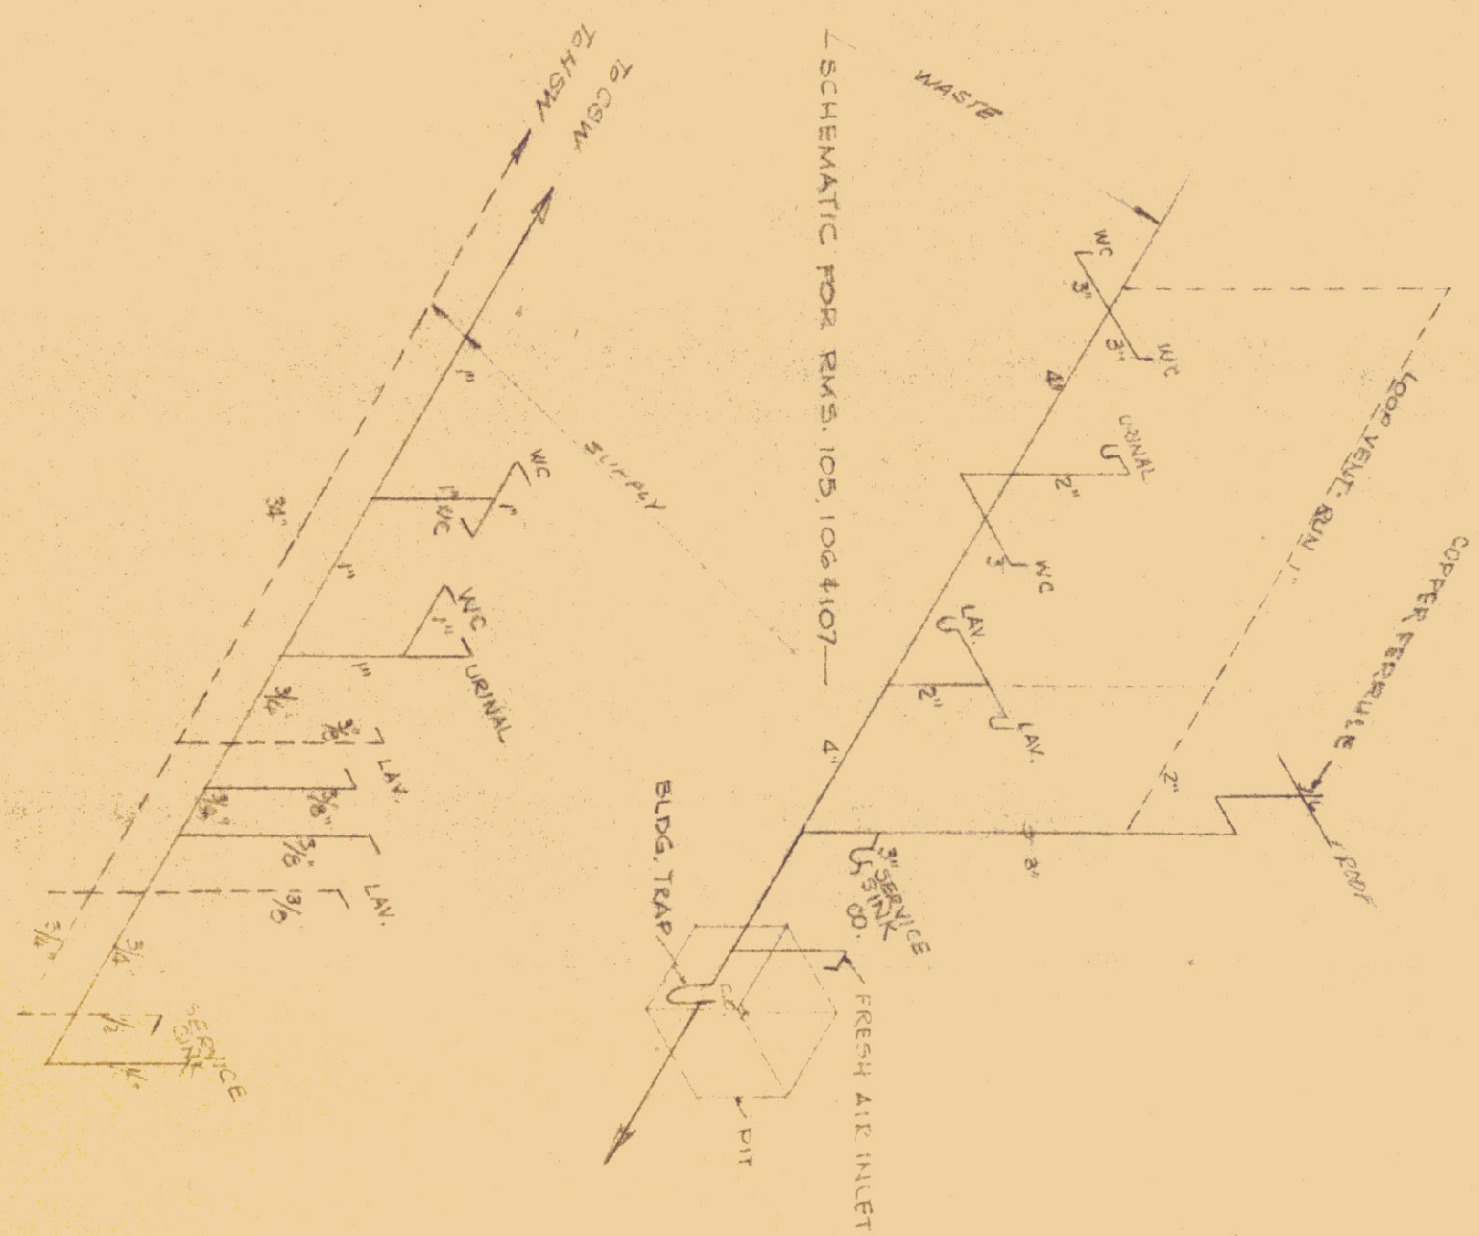


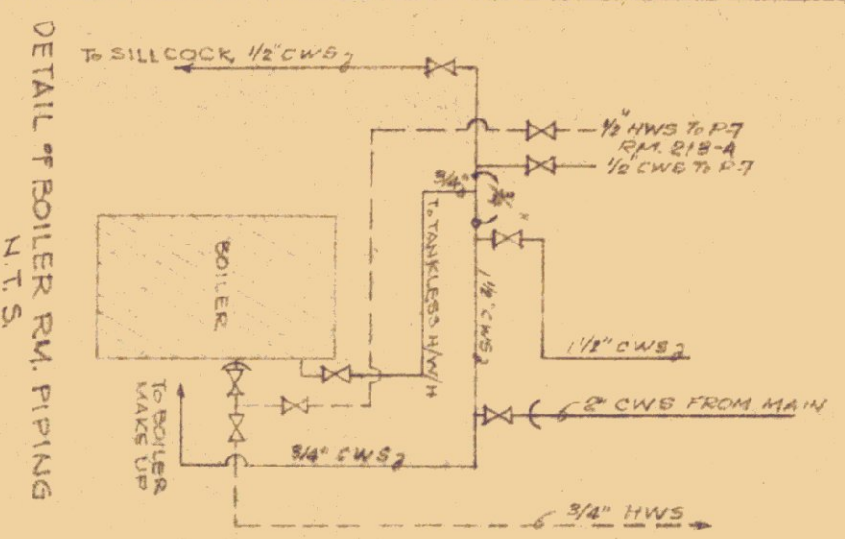

1. SEE PWG #2 FOR SEPTIC TANK AND LEACHING FIELD LAYOUT
2. PROVIDE 6" WIDE CONTINUOUS SHEET ABOVE BOTH LAYERS IN ROOM #16 (DOOR, WALL TO INT PART)
3. PROVIDE GATE VALVE SHUT OFFS FOR EACH BRANCH CIRCUIT HWS & CWS (ACCESSIBLE) GATE SIZE AS PIPE.
4. PROVIDE GATE VALVE SHUT OFFS AT EACH FIXTURE HWS & CWS (ACCESSIBLE) GATE SIZE AS PIPE.

REVISIONS		
REVISION	BY	DATE

STATE OF VERMONT
STATE BUILDINGS DIVISION
DEPARTMENT OF ADMINISTRATION
MONTPELIER, VERMONT

ST. JOHNSBURY OFFICE BUILDING
Plumbing Plan and Details

DATE: 4/26/72	DESIGNED BY:	CHECKED BY: G.N.M.	DWG NO. P-1
DRAWN BY: P.W.	APPROVED BY:	DATE: 6/30/72	<u>14</u> OF <u>17</u>