

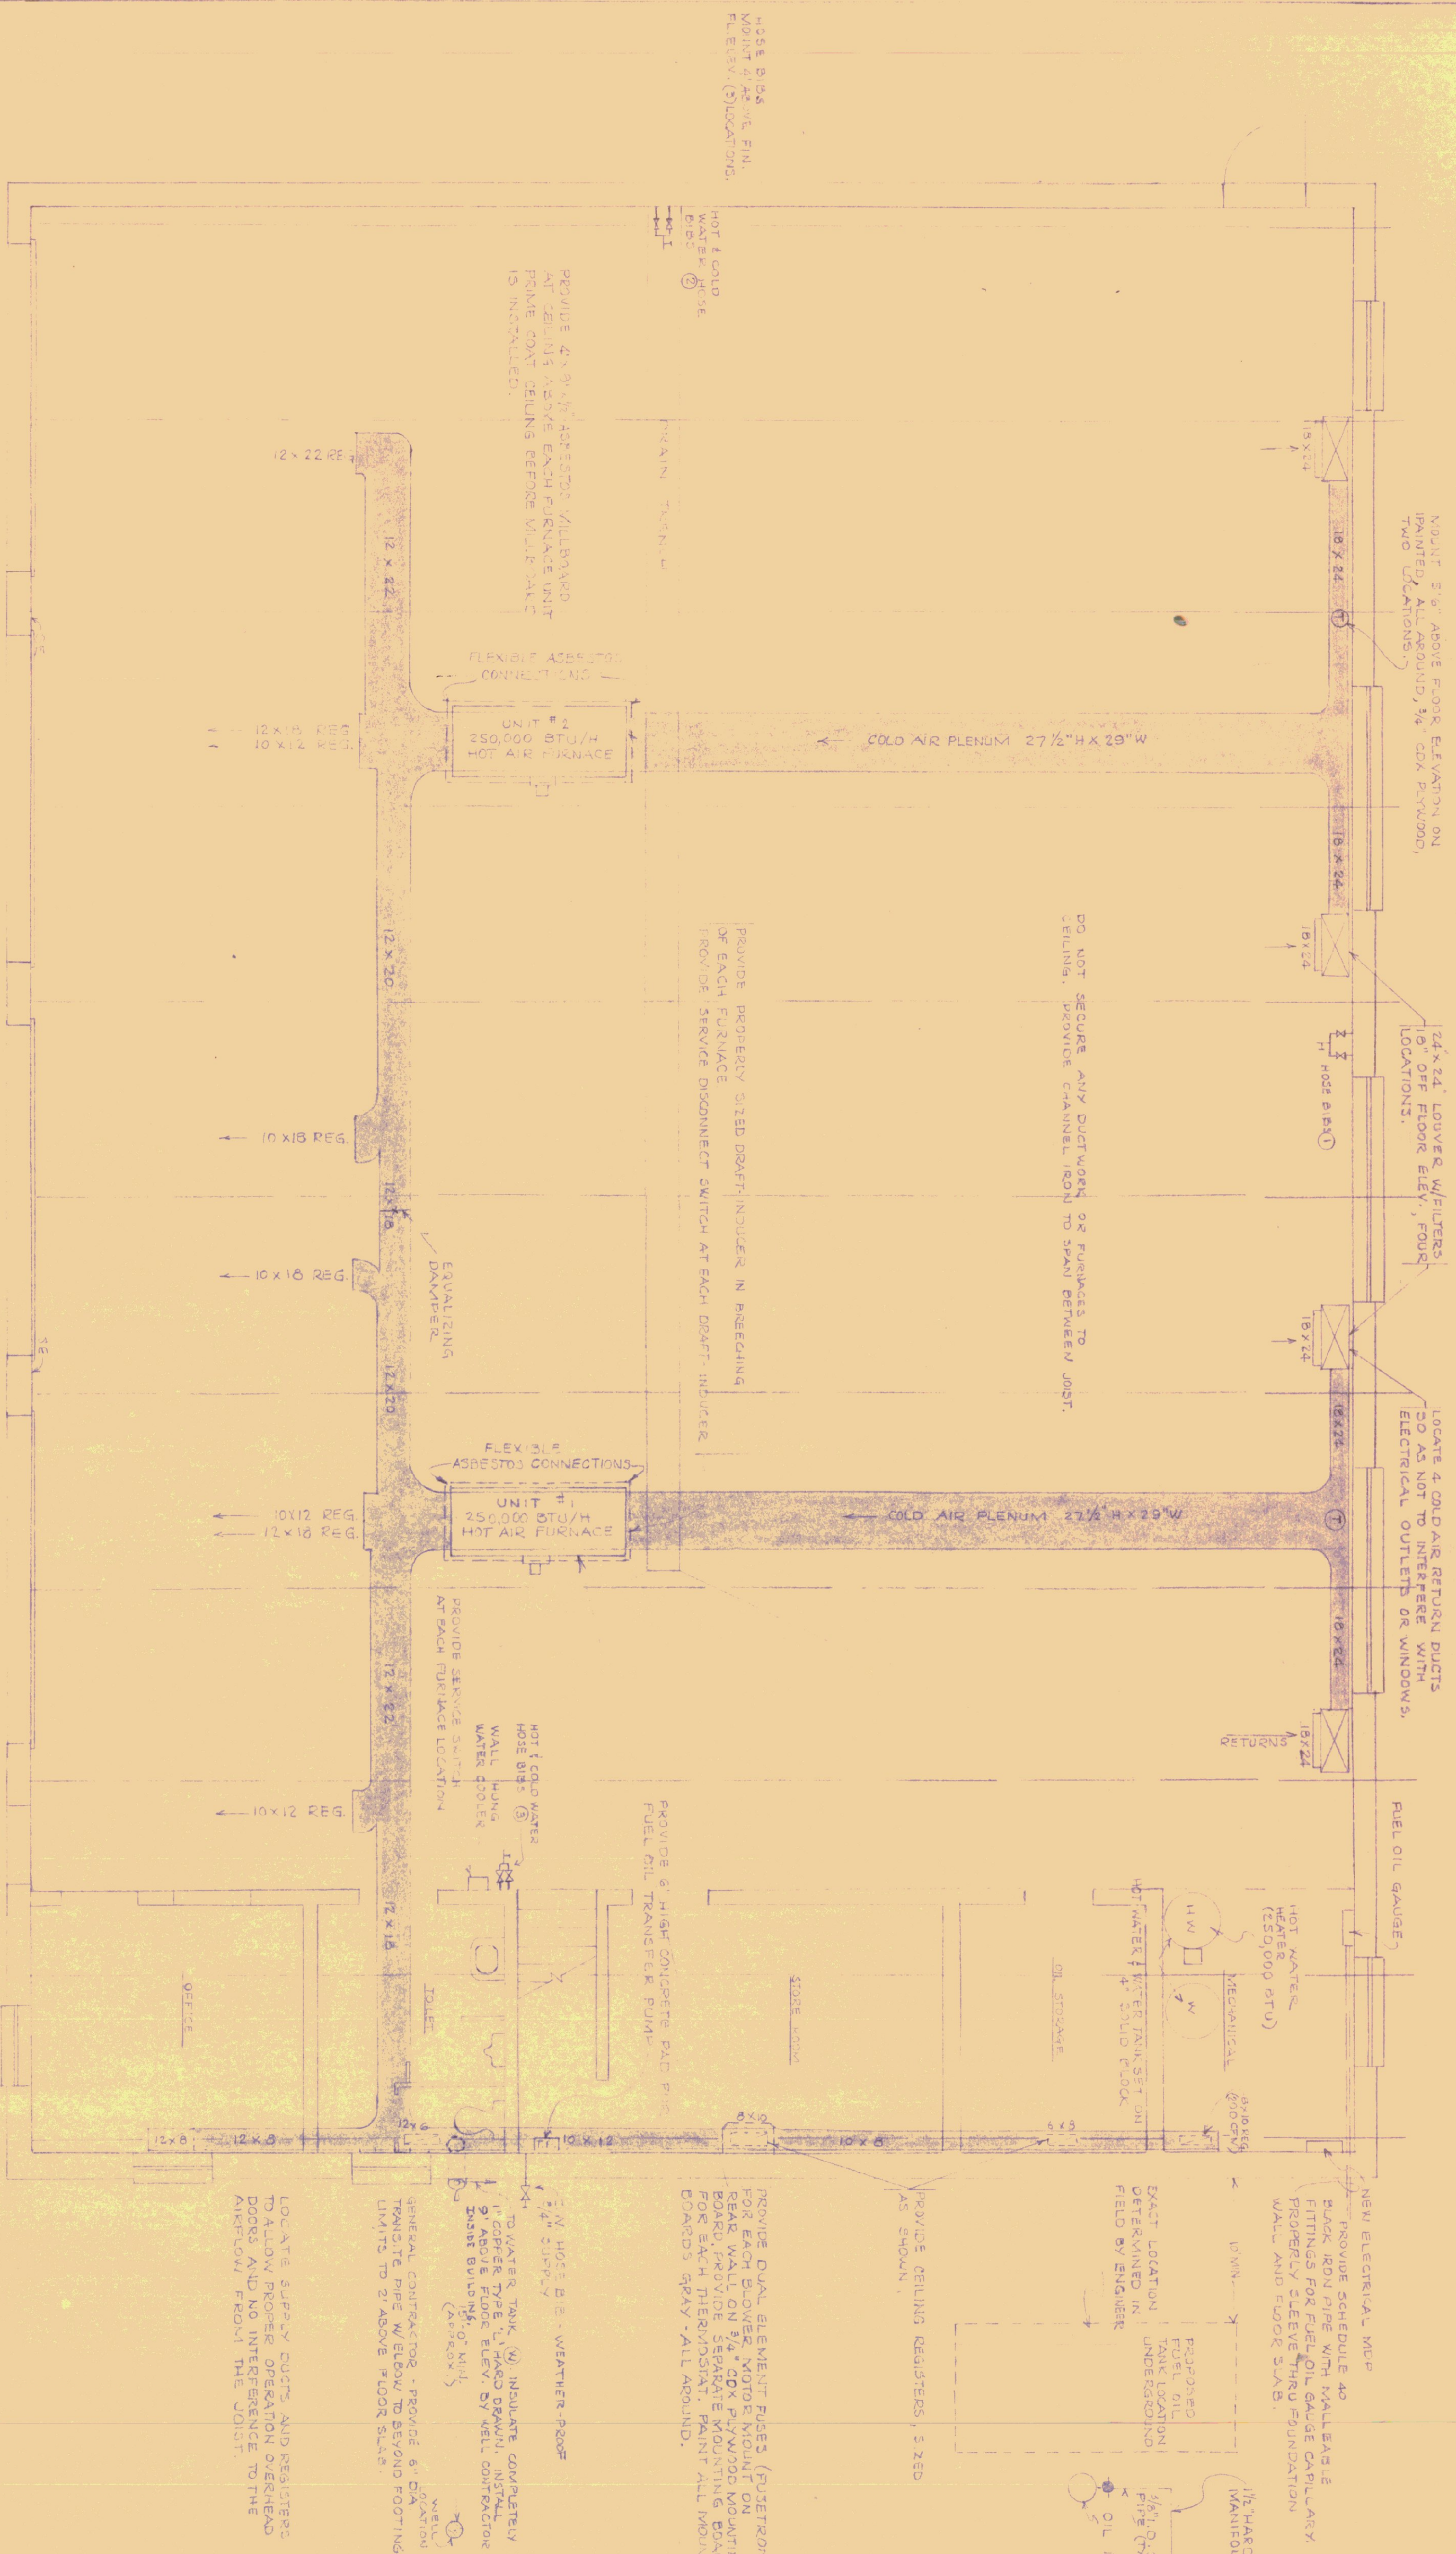


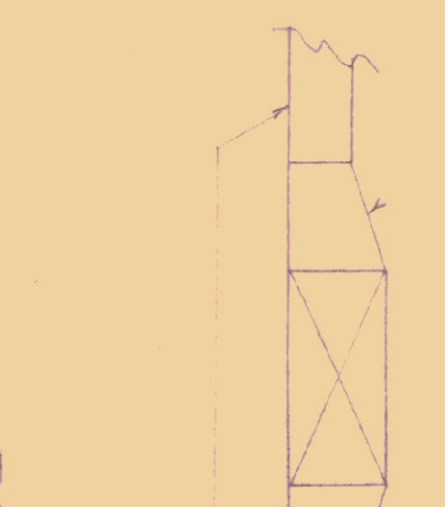

PLUMBING NOTE: PIPE SIZES

1. FROM 2001 WATER PRESSURE TANK AND 100 GPM WATER PRESSURE TANK TO COINTEGRATED WATER PRESSURE TANK
2. BETWEEN HOSE PIPES (1) AND (2)
3. FROM COINTEGRATED WATER PRESSURE TANK TO WATER PIPES (1) AND (2)
4. ALL COINTEGRATED WATER PRESSURE TANKS TO HAVE DRAINAGE PIPES TO THE OUTSIDE
5. ALL COINTEGRATED WATER PRESSURE TANKS TO HAVE DRAINAGE PIPES TO THE OUTSIDE
6. ALL COINTEGRATED WATER PRESSURE TANKS TO HAVE DRAINAGE PIPES TO THE OUTSIDE
7. ALL COINTEGRATED WATER PRESSURE TANKS TO HAVE DRAINAGE PIPES TO THE OUTSIDE
8. ALL COINTEGRATED WATER PRESSURE TANKS TO HAVE DRAINAGE PIPES TO THE OUTSIDE
9. ALL COINTEGRATED WATER PRESSURE TANKS TO HAVE DRAINAGE PIPES TO THE OUTSIDE
10. ALL COINTEGRATED WATER PRESSURE TANKS TO HAVE DRAINAGE PIPES TO THE OUTSIDE

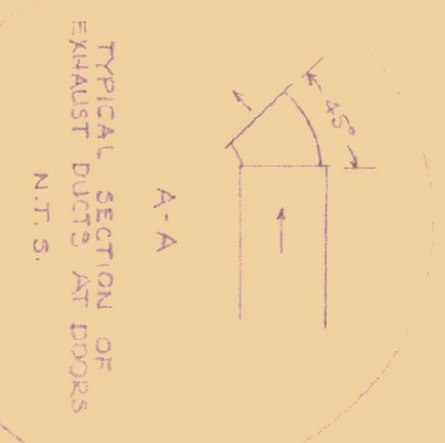


HEATING FLOOR PLAN

SCALE: 1/4" = 1'-0"

TYPICAL FURNACE DUCT ARRANGEMENT

NOT TO SCALE

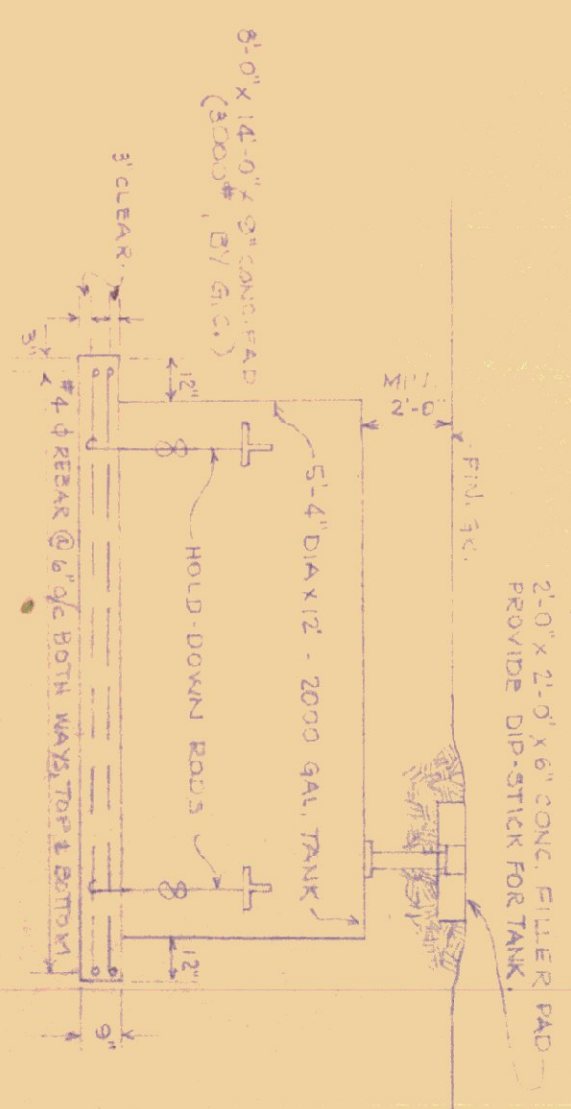

GENERAL NOTES

1. PROVIDE PERMANENT ALUMINUM TYPE FILTERS AT EACH FURNACE UNIT INTAKE AND AT EACH COLD AIR RETURN, INTAKE FILTERS ARE TO BE REMOVED FOR WASHING & REINSTALLATION.
2. ALL TUBES AND TUBES FOR REGISTERS IN DUCTWORK SYSTEM SHALL HAVE TURNING VANES (W/ADJUSTABLE) & SCOPES (FOR SCOPES SYSTEMS) BOTH HORIZONTAL AND VERTICAL.
3. ALL SUPPLY REGISTERS SHALL HAVE ADJUSTABLE DIRECTIONAL VANES.
4. ALL SUPPLY REGISTERS SHALL HAVE VOLUME DAMPERS.
5. ALL DUCTS ABOVE BOTTOM OF PAIR JOINTS.
6. ALL DUCTS ABOVE BOTTOM OF PAIR JOINTS.
7. IRON PIPE FITTINGS - ALL WALLEABLE.
8. ALL EXPOSED COPPER PIPING AND COPPER HANGERS TO BE GIVEN ONE (1) COAT CLEAR LACQUER.
9. ALL HOT AND COLD WATER DISTRIBUTION LINES ARE TO BE INSULATED AND INSTALLED MINIMUM OF 10' ABOVE GRADE BLOCKING TO PROVIDE A MINIMUM OF THREE (3) STEPS BETWEEN INSULATION AND OUTSIDE WALLS AND ALL DUCTWORK.
10. PRIME COAT DUCTWORK BEFORE INSTALLATION, ALL SURFACES THAT ARE COALESCED.
11. OVER EACH HEATING UNIT, ASBESTOS BOARD 4' x 8' x 1/4".
12. OVER EACH HEATING UNIT, ASBESTOS BOARD 4' x 8' x 1/4".
13. OVER EACH HEATING UNIT, ASBESTOS BOARD 4' x 8' x 1/4".
14. OVER EACH HEATING UNIT, ASBESTOS BOARD 4' x 8' x 1/4".
15. PROVIDE TWO (2) MOTORIZED LOWERS FOR EACH FURNACE, ONE EACH ON FRONT AND REAR OF BUILDING. SEE ELEVATIONS.
16. PROVIDE TWO (2) MOTORIZED LOWERS FOR EACH FURNACE, ONE EACH ON FRONT AND REAR OF BUILDING. SEE ELEVATIONS.

TYPICAL FUEL STORAGE & SUPPLY DETAIL

NOT TO SCALE

ALL UNDERGROUND PIPES SHALL HAVE A MINIMUM OF 18" COVER, AND SHALL HAVE A MINIMUM OF 12" COVER AROUND OVERLAP.

DENOTES FUSIBLE LINK SHUTOFF

U.S. FUEL TANK

FUEL OIL SUPPLY LINE

FUEL OIL SUPPLY LINE

