


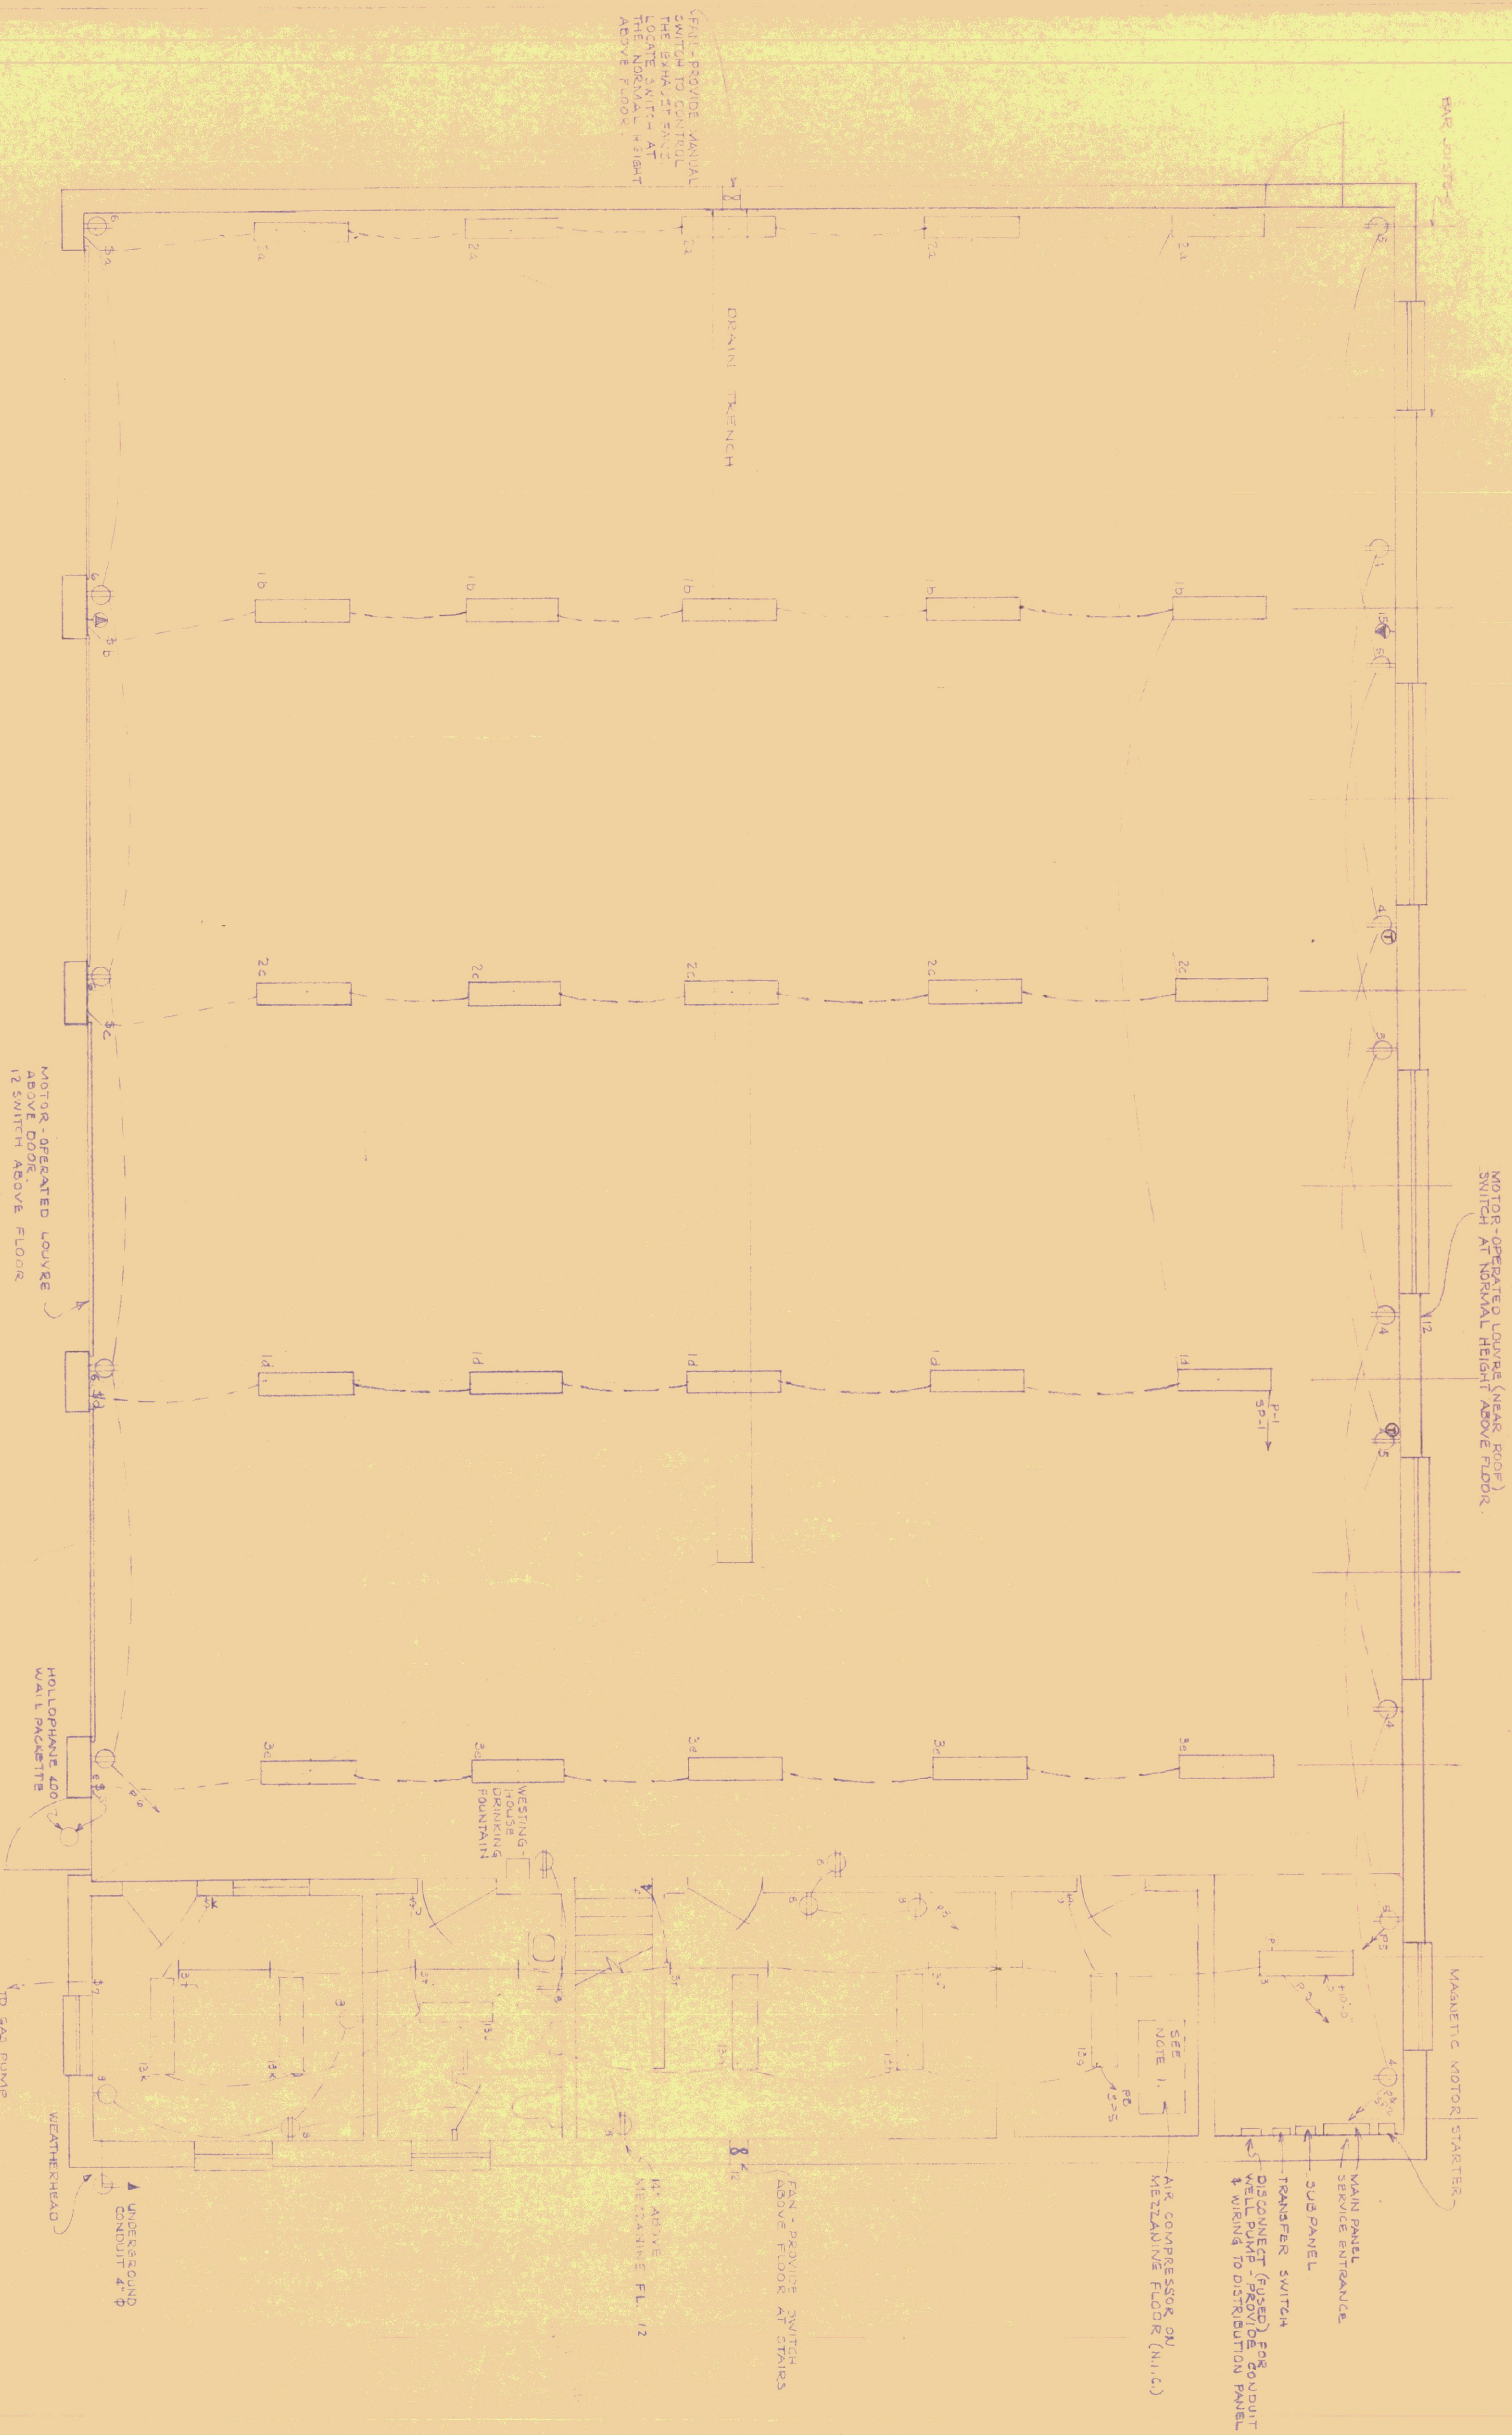

ELECTRICAL FLOOR PLAN
SCALE: 1/4" = 1'-0"

- GENERAL NOTES
- 1. SMITHBART TIGHT 20-TEC-2-40S (MOUNT ON BOTTOM OF JOISTS)
 - 2. WESTINGHOUSE 1-TUBE RS STRIP, 5 STIMOR (MOUNT ON BOTTOM OF JOISTS)
 - 3. SMITHBART CONDUIT, 6 DIA-2-40 (SURFACE MOUNT TO CEILING)
 - 4. THERMOSTAT - CONNECT TO CIRCUIT 12 AND TO SUBPANEL CIRCUIT 4 - THERMOSTAT 5-6" OFF FLOOR
 - 5. DO AIR WELDER OUTLET
 - 6. RUN 1" CONDUIT FROM MAIN PANEL THRU MOTOR STARTER TO WALL AT AIR COMPRESSOR, ALL CONDUIT TO BE RUN IN BLOCKWORK FOR RECEPTACLES. ALL EXPOSED CONDUIT IS TO BE PAINTED.

SPECIAL NOTE (EXTRA BAYS)

THE CONTRACTOR IS TO ADD ELECTRICAL FIXTURES, SWITCHES, RECEPTACLES, AND CONDUIT FOR ADDITIONAL BAY SIMILAR TO TYPICAL BAY. ADD ONE (1) EXTRA MOTORIZED LOUVER WITH SCREEN FRONT AND REAR WITH SWITCHES FOR A FIVE (5) BAY GARAGE, LOCATION OPPOSITE HEATING UNITS. GENERAL CONTRACTOR TO BLOCK-OUT, POUR UNTEL, AND CONCRETE SILL FOR SAME.

STATE OF VERMONT			
STATE BUILDINGS DIVISION			
DEPARTMENT OF ADMINISTRATION			
MONTPELIER, VERMONT			
STANDARD HIGHWAY GARAGE BUILDING			
4 BAY			
ELECTRICAL			
DATE: 7/2/73	CHECKED BY: J. V. Moore	DWG. NO. E-1	
DRAWN BY: J. V. Moore	APPROVED BY: J. V. Moore	OF	