



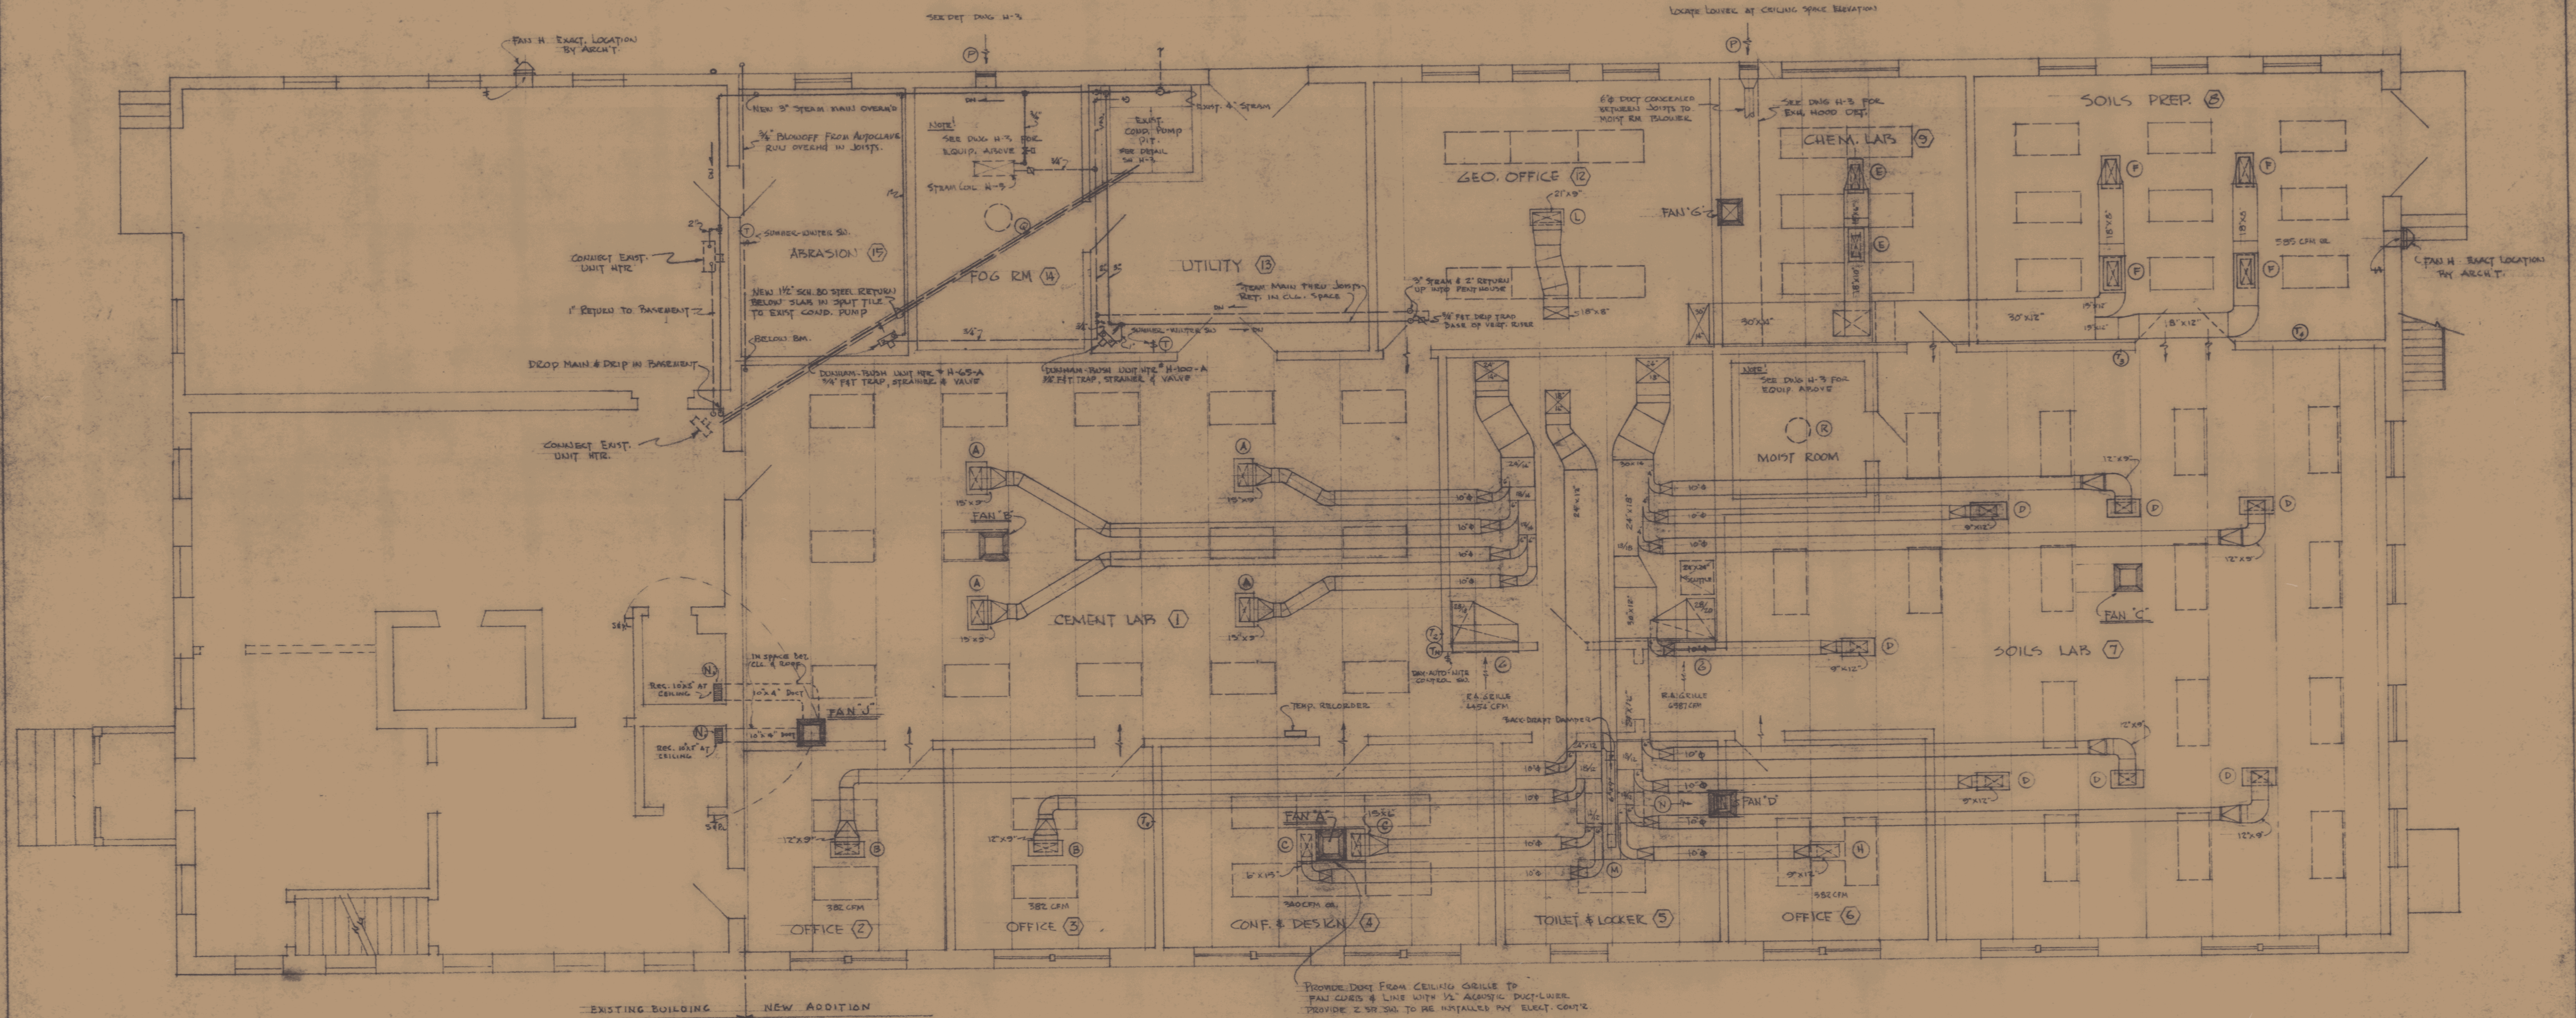

FIRST FLOOR PLAN - HEATING & AIR CONDITIONING
SCALE: 1/4" = 1'-0"

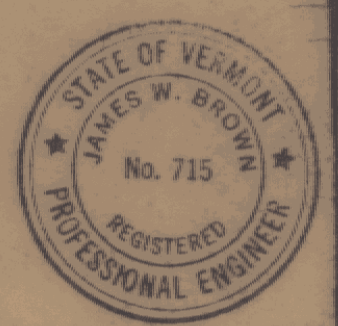

JENNISON ENGINEERING INC.
95 COLLEGE ST. FARMINGTON, VT.

ADDN TO VERMONT
STATE HIGHWAY LABORATORY
MONTPELIER, VERMONT

GORDON G. WOODS
ARCHITECTS & ENGINEERS
ST. JOHNSBURY, VERMONT

DESIGNED BY B.W.
CHECKED BY B.W.
DATE MAR-61
H-1